


- AS-BUILT NOTES:**
CEILING & BULKHEADS REVERSED WITH AS-BUILT REVISIONS NOT CLOUDED
- CEILING NOTES:**
1. TYPICAL GYPSUM BULKHEAD W/ ACUSTIC INSULATION
2. CEILING TYPE C1 W/ ACUSTIC INSULATION AT BATHROOMS AND LAUNDRY CLOSETS TYP.
3. KITCHEN BULKHEAD @ 2450mm AFF TYP. U.N.O. @ 2200mm AFF ON LEVELS 1 AND 4
4. ALL PLUMBING PENETRATING SLAB ABOVE TO BE WRAPPED W/ 38mm ACUSTIC BATT EXCEPT IN BATHROOM CEILINGS.
5. PARTITIONS AROUND C1 CEILINGS TO BE FILLED W/ ACUSTIC BATT ABOVE THE CEILING. EXTEND GYPSUM TO US SLAB ABOVE ON ONE SIDE OF PARTITION MIN.
6. WHERE PLUMBING FROM ABOVE IS LOCATED OVER A ROOM BELOW OTHER THAN A BATHROOM PROVIDE AN INSULATED C1 CEILING, PLUS WRAP THE PLUMBING IN ACUSTIC BATT.

- PLAN DRAWING LEGEND:**
DENOTES PAINTED CIA GYPSUM BULKHEAD AT 2450 AFF UNLESS NOTED
(MTL) YELLOW METAL PANEL CLADDING
(WTA) EXTERIOR WALL ASSEMBLIES W/ UNLESS NOTED OTHERWISE
- Denotes BARRIER-FREE DESIGNATED RESIDENTIAL SUITE
Denotes ROOF DRAIN AND ROOF DRAINAGE LAYOUT. REFER ALSO TO SLAB EDGE PLANS FOR SLOPES AND SLAB ELEVATIONS
- REFER TO DWG. A420 FOR DETAILS OF WINDOW WASHING SYSTEMS
AP ANCHOR POINT
DB DAWT BASE
RDB RECESSED DAWT BASE
- RRA RECESSED ROOF ANCHOR
RA ROOF ANCHOR
RWA ROOF ANCHOR - WALL MOUNTED
RS WINDOW WASHING RIGGING SLEEVE

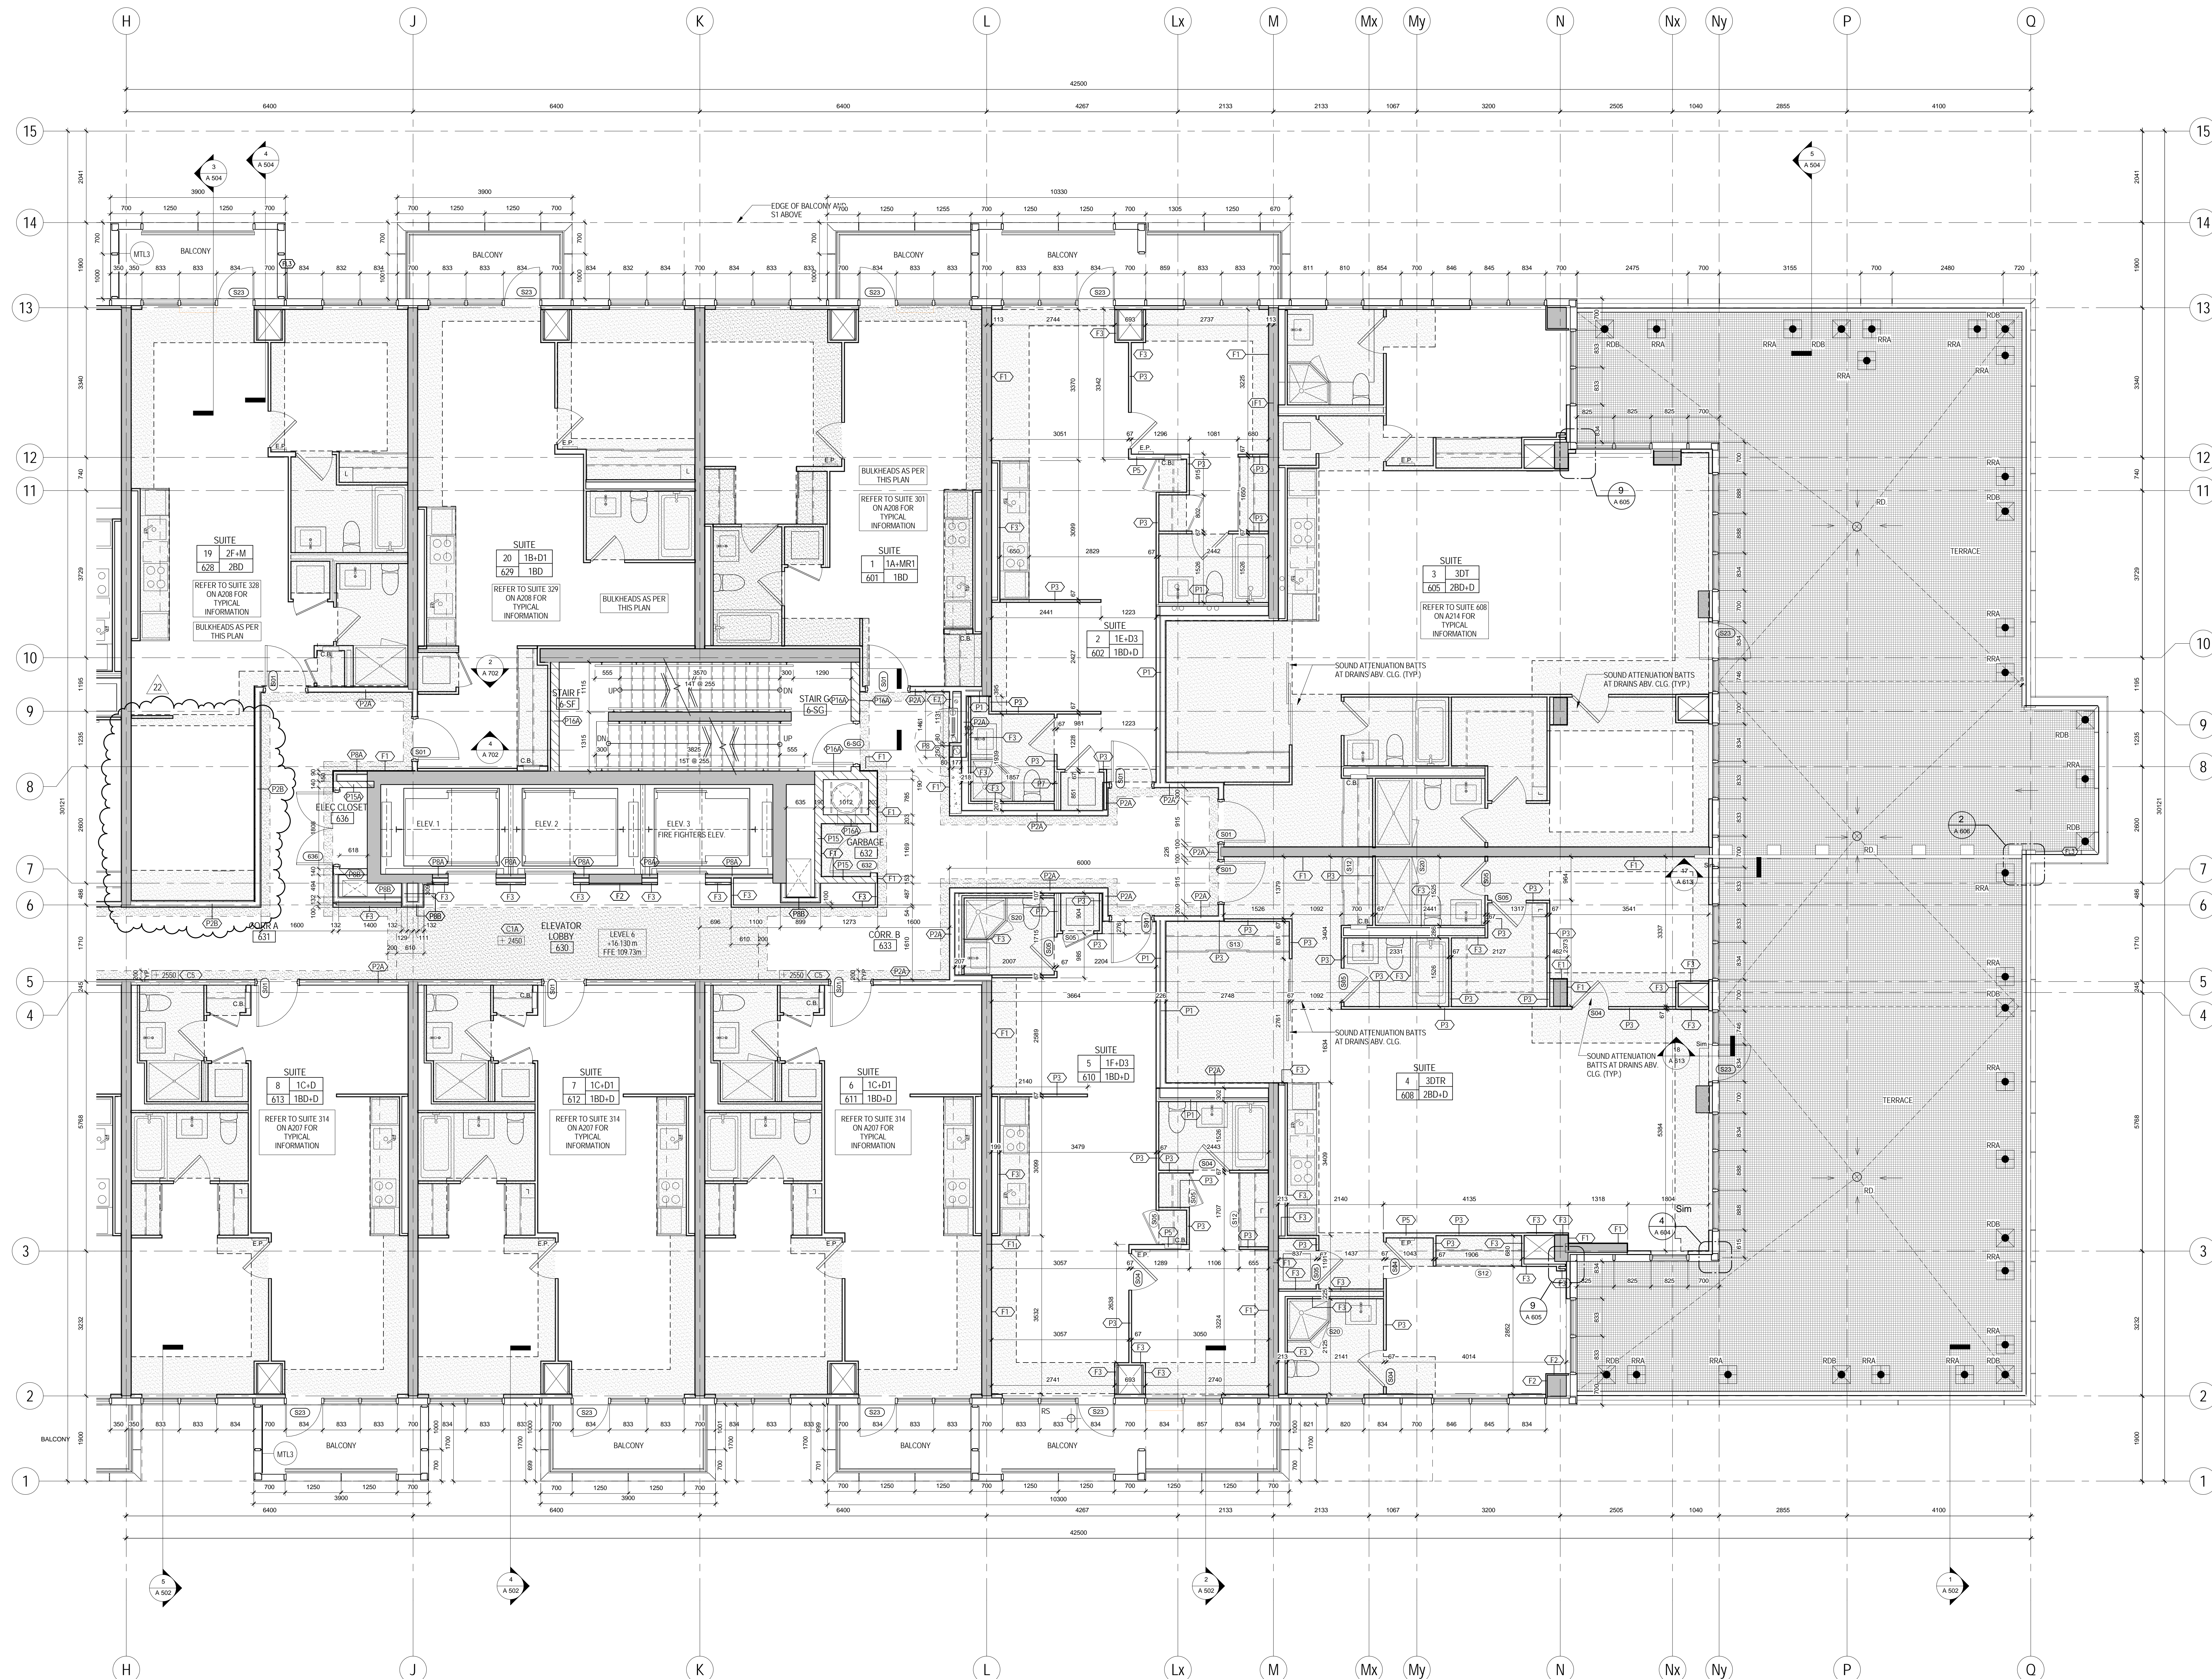

METRIC SCALE DRAWING
FIRST FLOOR ELEV. +93.60m

No.	ISSUED/REVERSED FOR	DATE
1	Issued for SPA	2013-03-28
2	Issued for Coordination	2013-04-11
3	Issued for Coordination	2013-04-11
4	Revised by SPA	2014-01-10
5	Issued for Coordination	2014-02-28
6	Issued for Elevator Tender	2014-04-07
7	Issued for Coordination	2014-05-21
8	Issued for O&M Completion	2014-06-23
9	Issued for Permit	2014-06-26
10	Issued for Coordination	2014-06-23
11	Revised by Permit	2014-07-02
12	Revised by Permit	2014-08-22
13	Issued for Tender	2014-08-28
14	Issued for Tender	2014-09-22
15	Issued for Flooring Tender	2015-03-30
16	Issued for Permit	2015-05-20
17	Issued for AS-04	2015-06-17
18	Issued for Drywall Tender	2015-08-19
19	Issued for Drywall Tender Add #1	2015-09-14
20	Issued for AS-15	2015-09-23
21	Issued for AS-20	2015-11-23
22	Issued for AS-24	2016-02-22

SQ ALEXANDRA PARK - BLOCK 11
38 CAMERON ST. TORONTO, ONTARIO M5T 2H2

project no. 12-115
scale: As indicated
drawn by: TA
reviewed by: SA
date: 2014-09-22

Teuple Architects
LEVEL 6 PLAN NORTH