



**DO NOT SCALE DRAWINGS.**

CONTRACTOR MUST VERIFY ALL DRAWINGS, DIMENSIONS, DETAILS AND SPECIFICATIONS, AND REPORT ANY DISCREPANCIES TO UNION31 INC. BEFORE PROCEEDING WITH WORK. MATERIALS MAY NOT BE SUBSTITUTED WITHOUT WRITTEN APPROVAL FROM UNION31 INC.  
ALL DRAWINGS AND SPECIFICATIONS ARE INSTRUMENTS OF SERVICE AND THE PROPERTY OF UNION31 INC. WHICH MUST BE RETURNED AT THE COMPLETION OF THE WORK.

PRINTED: 23-Aug-14

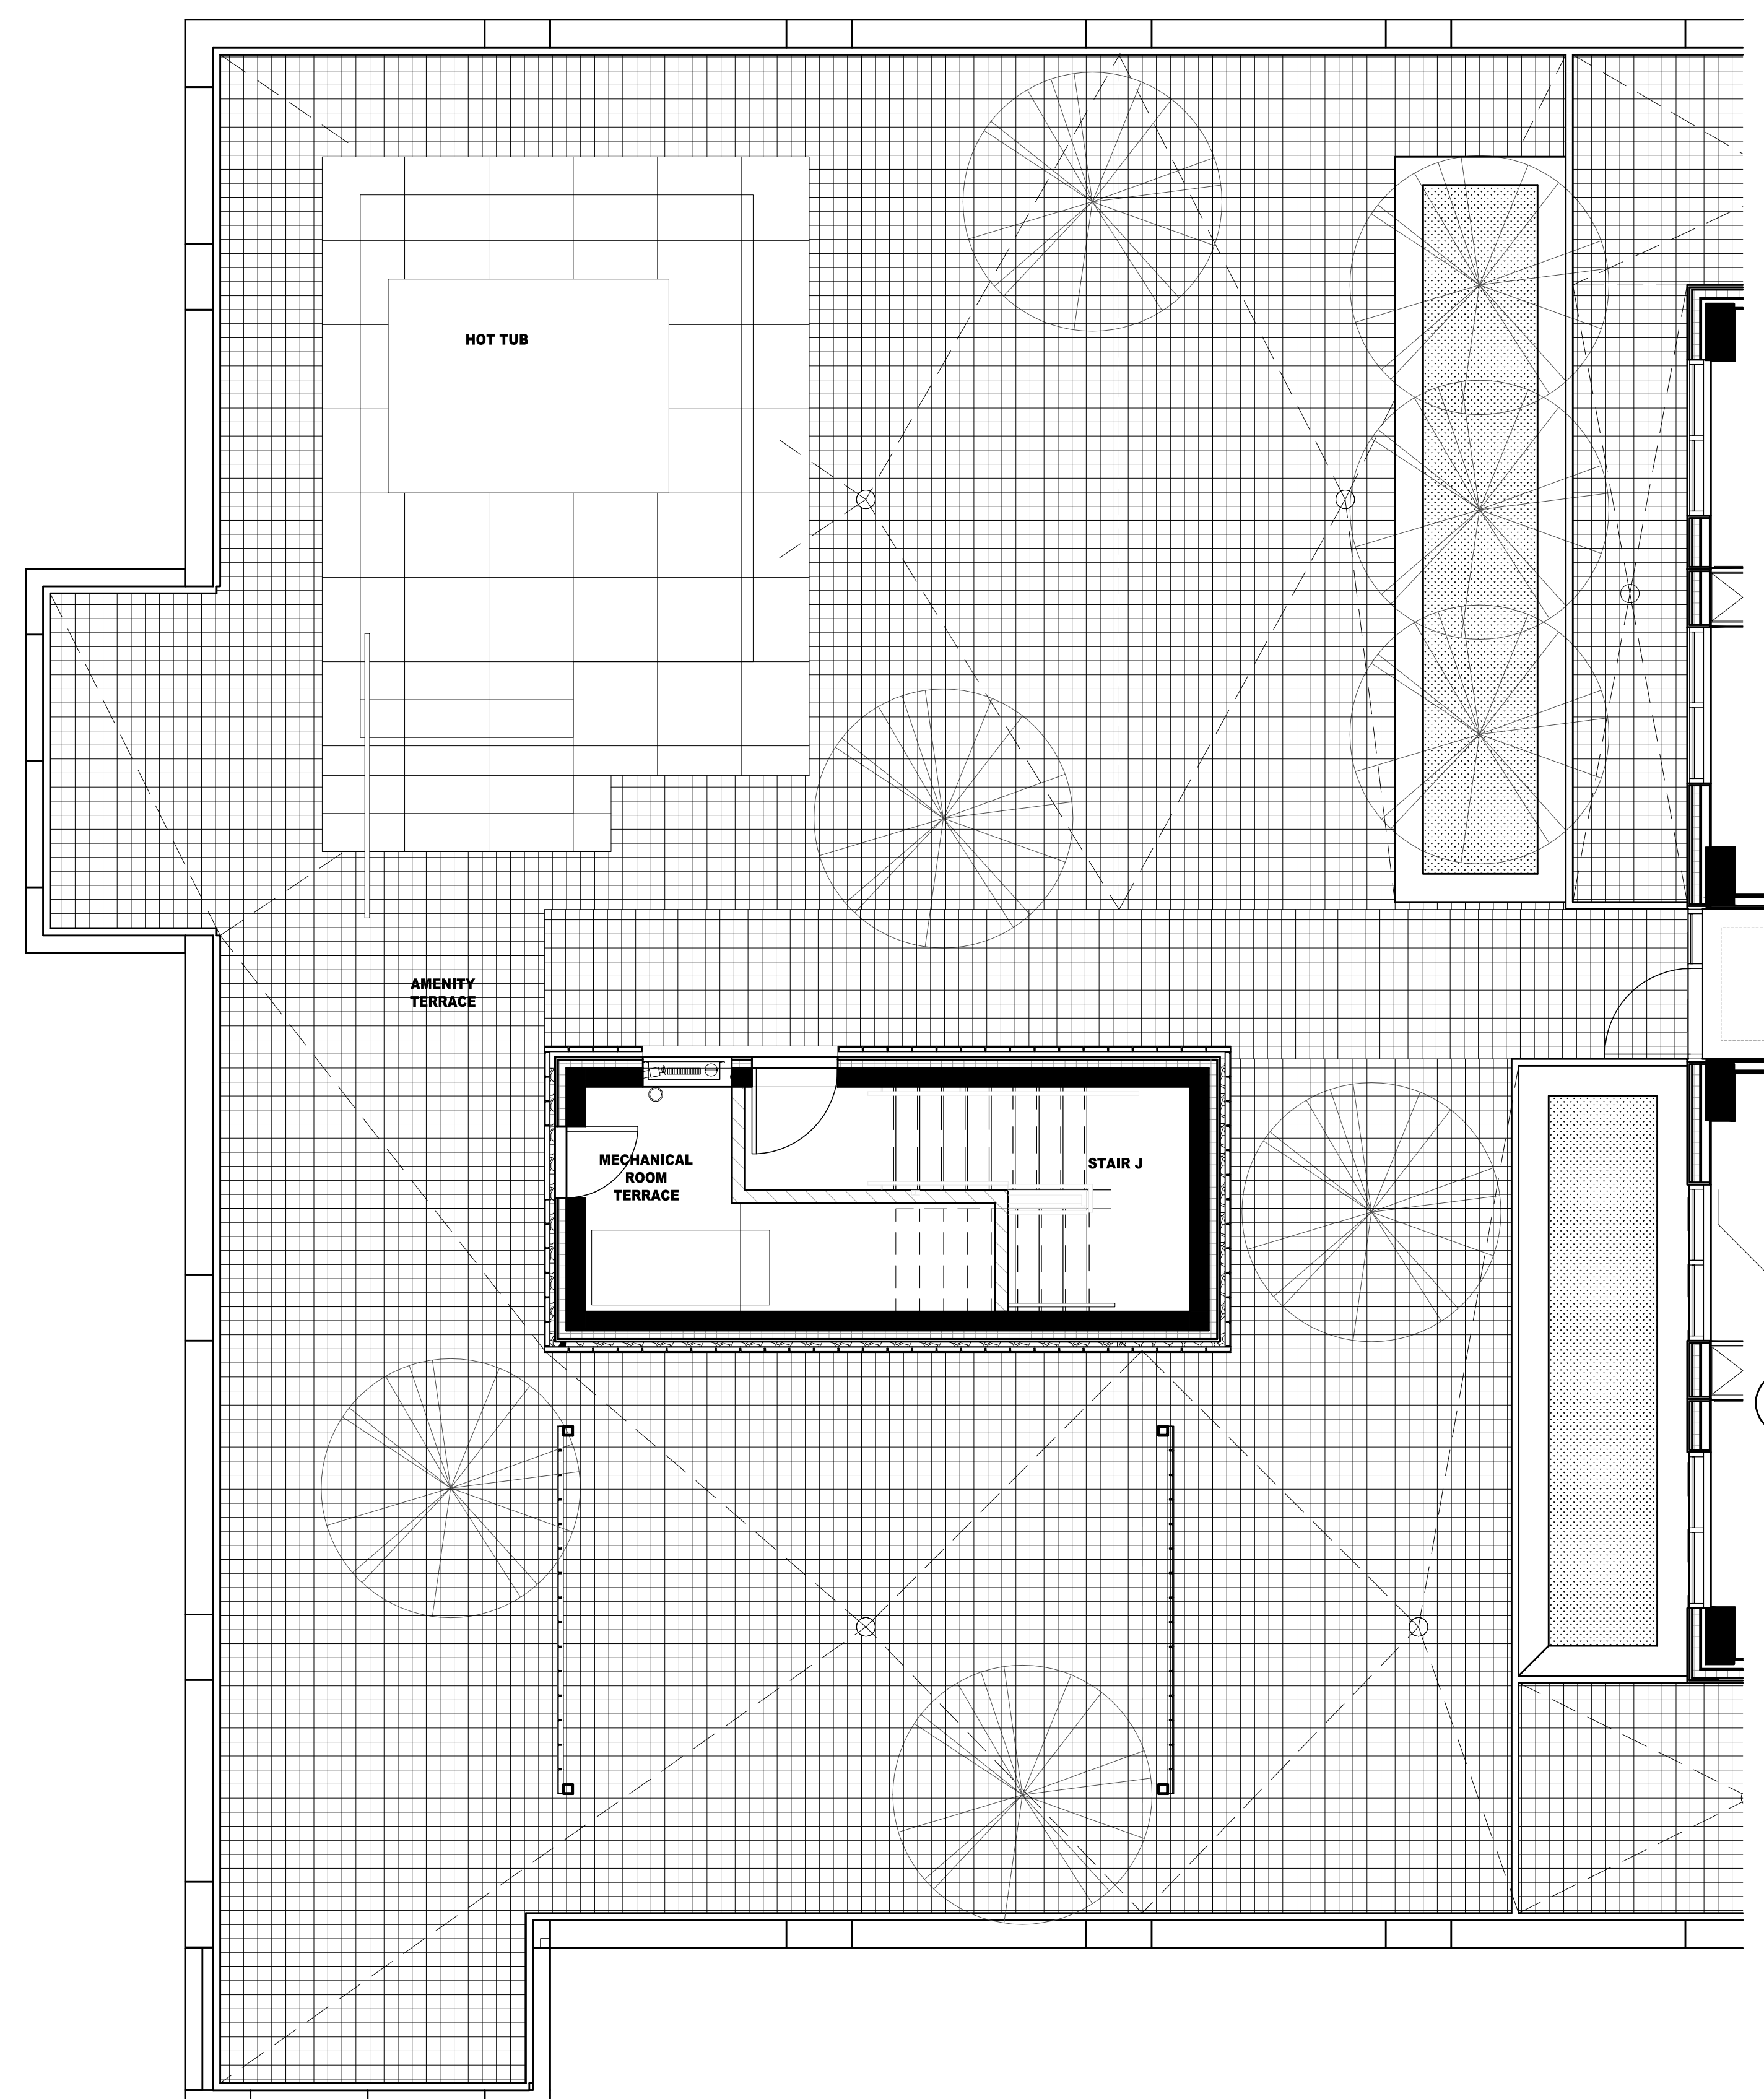

1 FURNITURE & POWER PLAN  
ID1.9.2 9TH FLOOR SCALE 1:50

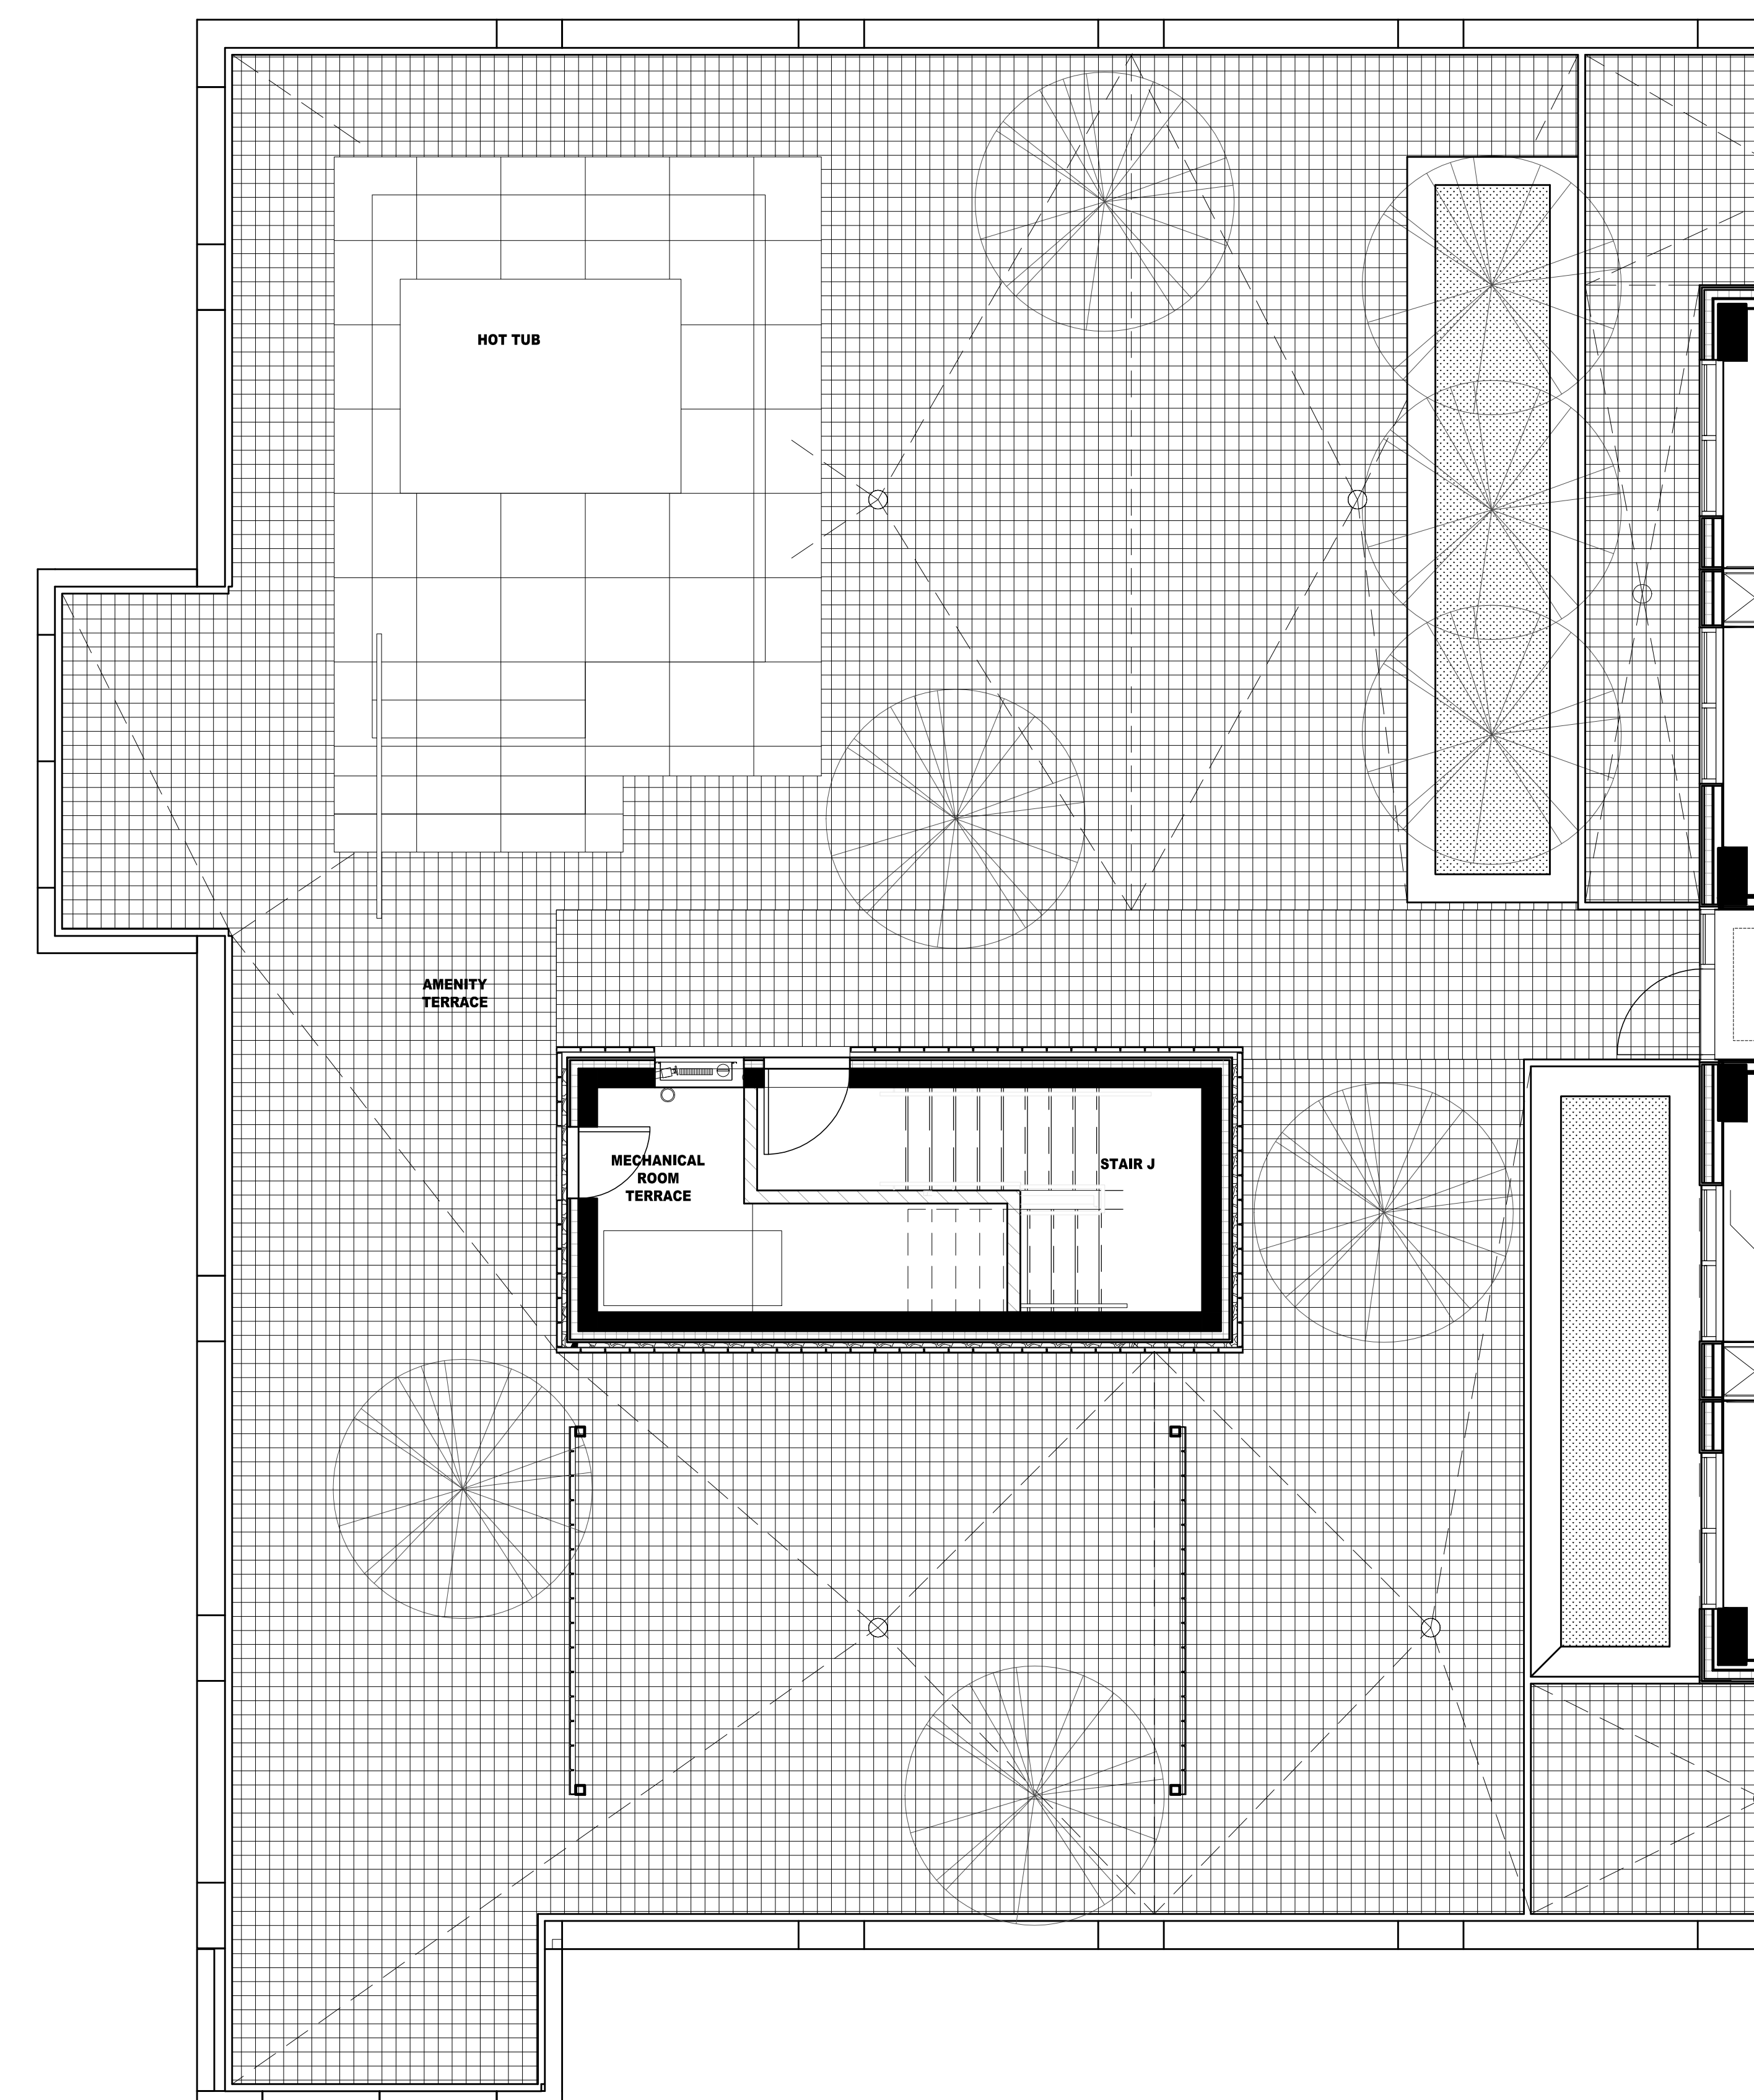

2 FLOOR FINISHES PLAN  
ID1.9.2 9TH FLOOR SCALE 1:50

NO.	DATE	COMMENTS	INI

REVISIONS:

UNION31

UNION31 INC.  
183 BATHURST STREET, STE. 201  
TORONTO, ON, M5T 2R7, CANADA  
TEL: 416-597-1576 FAX: 416-597-2139

PROJECT NAME:	ALEXANDRA PARK MAIN BUILDING
BLOCK:	11
ON, Canada	
PROJECT NO.:	13-949
DRAWINGS:	9TH FLOOR AMENITY TERRACE FURNITURE & POWER PLAN & FLOOR FINISHES PLAN
DATE STARTED:	07 AUG / 13
SCALE:	1 : 50
DRAWN BY:	AP
APPROVED BY:	KC
DRAWING NO.:	ID 1.9.2