


**DO NOT SCALE DRAWINGS.**

CONTRACTOR MUST VERIFY ALL DRAWINGS, DIMENSIONS, DETAILS AND SPECIFICATIONS, AND REPORT ANY DISCREPANCIES TO UNION 31 INC. BEFORE PROCEEDING WITH WORK. MATERIALS MAY NOT BE SUBSTITUTED WITHOUT WRITTEN APPROVAL FROM UNION 31 INC.  
ALL DRAWINGS AND SPECIFICATIONS ARE INSTRUMENTS OF SERVICE AND THE PROPERTY OF UNION 31 INC. WHICH MUST BE RETURNED AT THE COMPLETION OF THE WORK.

PRINTED: 28-May-15

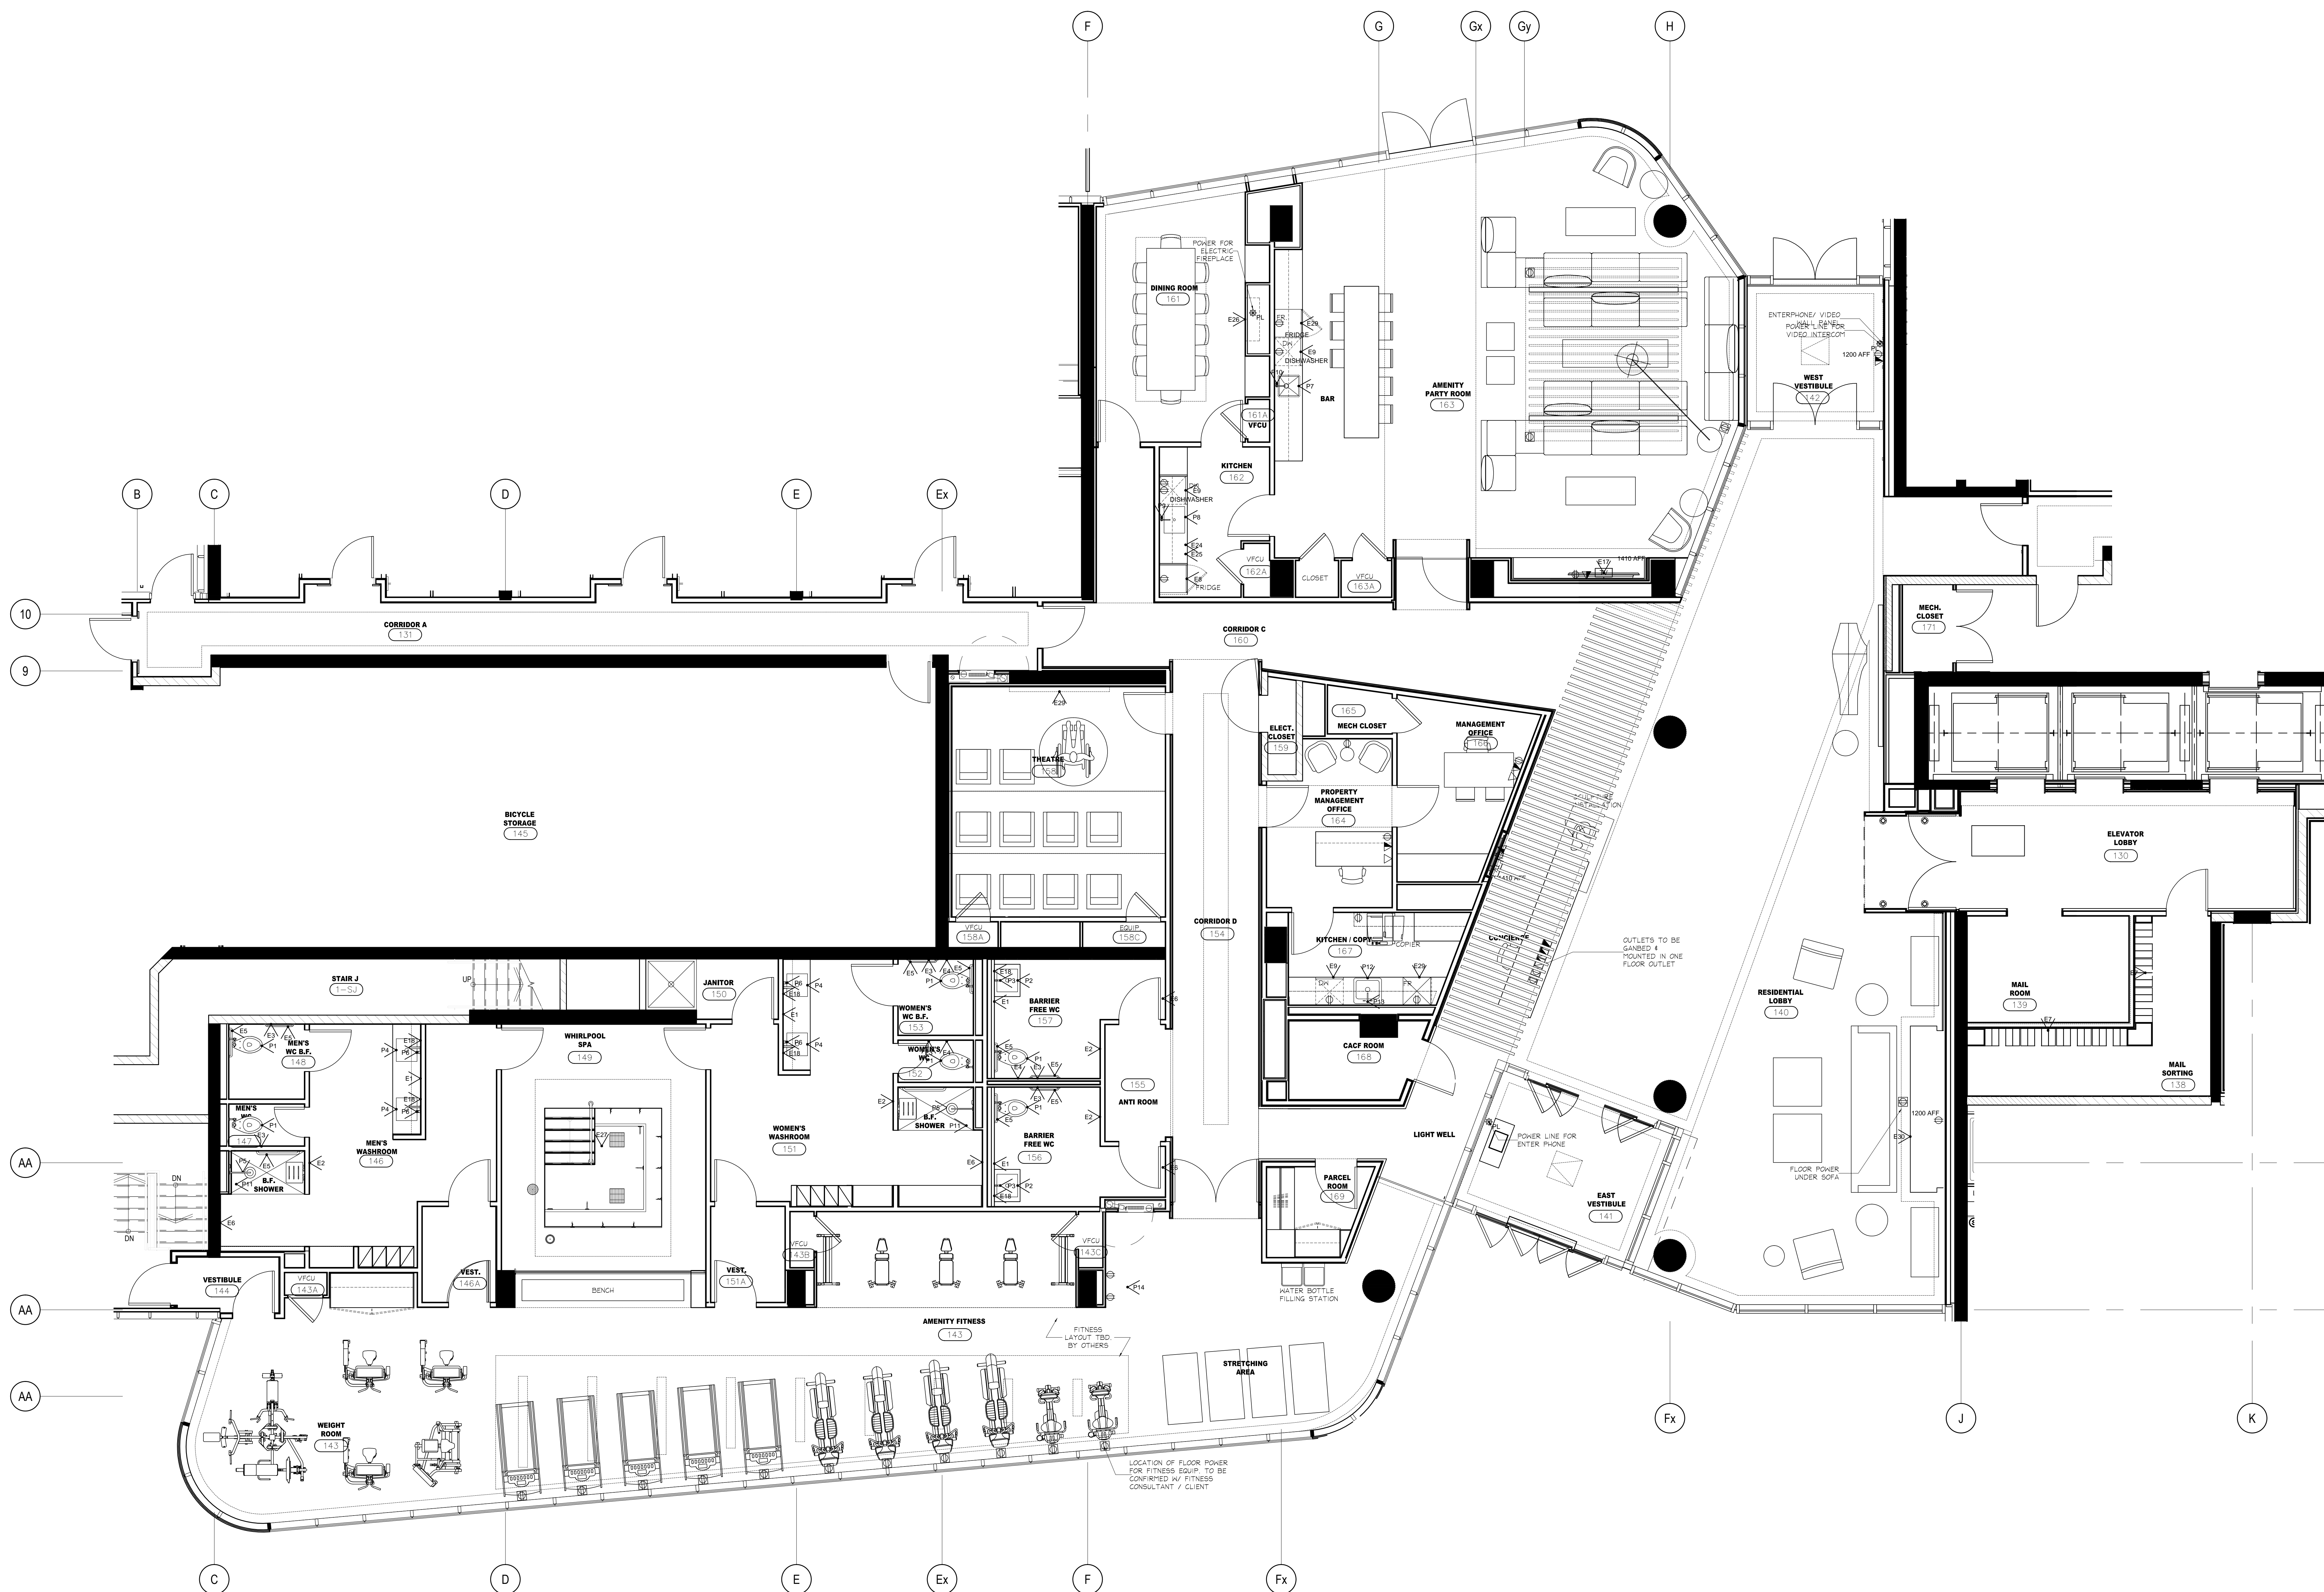

NO.	DATE	COMMENTS	INI
03	06 MAR / 15	ISSUED FOR TENDER	AP
02	26 JAN / 15	ISSUED FOR TENDER	AP
01	22 AUG / 14	ISSUED FOR PERMIT	AP

**UNION 31**  
 UNION31 INC.  
 183 BATHURST STREET, STE. 201  
 TORONTO, ON, M5T 2R7, CANADA  
 TEL: 416-597-1576 FAX: 416-597-2139

PROJECT NAME:		<b>ALEXANDRA PARK MAIN BUILDING</b>	
BLOCK 11		ON, Canada	
PROJECT NO.:	13-949	DRAWING NO.:	
GROUND FLOOR FURNITURE & POWER PLAN		DATE STARTED:	07 AUG / 13
SCALE:	1 : 50	DRAWN BY:	AP
APPROVED BY:	KC	DRAWING NO.:	<b>ID</b>
		SCALE:	<b>1.1.2</b>

**1** FURNITURE & POWER PLAN  
 GROUND FLOOR SCALE 1:50