

DOOR SCHEDULE

Where Applicable:

- All doors, frames, and hardware are Designer's suggestions only. Specifications are to be confirmed by the Architect and door supplier in accordance with applicable building codes.

TYPICAL

S01 (Suite Entry)
215mm high solid core slab wood door for paint finish, hardware to be signature series, Detroit, satin chrome finish, complete with low profile deadbolt assembly to match, provide standard peep hole, hinges, self-closer all in satin chrome finish, door frame to be midframe metal door forming complete with 90 minute fire rating, sub-casing as per developers specification on unit side, refer to elevation for corridor side.
**GF, 2F, and 13F will have 240mm high suite entry door height to match interior suite doors.
Supplier: **Citywide Door and Hardware**
Tony Bancheff
(905) 264-4461

(Typical floors - electrical closet door, mechanical doors, refuse doors)
215mm high hollow core metal doors as per architects specifications, for paint finish as per wall finishes plan, hardware to be Schlage Architectural Hardware, lever style pulls, S Series model Jupiter, IN #026 finish (satin chrome), provide hinges, self closer all in satin chrome finish.
**GF, 2F, and 13F will have 240mm high door height to match suite entry doors.
Supplier: **Citywide Door & Hardware**

(Typical Exit Signs)
215mm high hollow core metal doors as per architects specifications, for paint finish as per wall finishes plan, hardware to be Schlage Architectural Hardware, lever style pulls, S Series model Jupiter, IN #026 finish (satin chrome), provide hinges, self closer all in satin chrome finish.
**GF, 2F, and 13F will have 240mm high door height to match suite entry doors.
Supplier: **Citywide Door & Hardware**

PARKING LEVEL 2

P201.1, P201.3 (P2 Elevator Lobby)
215mm high aluminum door, complete with vision glass as per architects specifications, for paint finish as per curtain wall finish (TBD), hardware to be Schlage Architectural Hardware, lever style pulls, S series model Jupiter, IN#026 (satin chrome), provide hinges self closer all in satin chrome finish.
Supplier: **Citywide Door and Hardware**

P201.2 (Elevator Lobby to Vestibule)
215mm high 90 min rated hollow core metal door, complete with vision lite as per architect's specifications, for paint finish as per wall finishes plan, hardware to be Schlage Architectural Hardware, lever style pulls, S series model Jupiter, IN#026 (satin chrome), provide hinges self closer all in satin chrome finish, Electronic strike TBD as per architects specification.
Supplier: **Citywide Door and Hardware**

PARKING LEVEL 1

P116.2, P101 (P1 Lobby Vestibules)
215mm high aluminum door, complete with vision glass as per architect's specifications, for paint finish as per curtain wall finish (TBD), hardware to be Schlage Architectural Hardware, lever style pulls, S series model Jupiter, IN#026 (satin chrome), provide hinges self closer all in satin chrome finish.
Supplier: **Citywide Door and Hardware**

P110.1, P110 (Elevator Lobby to Vestibule)
215mm high 90 min rated hollow core metal door, complete with vision lite as per architect's specifications, for paint finish as per wall finishes plan, hardware to be Schlage Architectural Hardware, lever style pulls, S series model Jupiter, IN#026 (satin chrome), provide hinges self closer all in satin chrome finish, Electronic strike TBD as per architects specification.
Supplier: **Citywide Door and Hardware**

P117 (Staff Room)
215mm high 90 min rated hollow core metal door, complete with vision lite and sidelight as per architect's specifications, for paint finish as per wall finishes plan, glass for frosted film, hardware to be Schlage Architectural Hardware, lever style pulls, S series model Jupiter, IN#026 (satin chrome), provide hinges self closer all in satin chrome finish, Electronic strike TBD as per architects specification.
Supplier: **Citywide Door and Hardware**

GROUND FLOOR

131.1 CORRIDOR A TO EXTERIOR
215mm high, as per architect's specifications.

133 CORRIDOR B (GARAGE ACCESS)
213mm high as per architect's specifications.

138 MAIL SORTING
240mm high custom solid core wood door for wood finish and base as per wall finishes plan and elevations, concealed casing, hardware to be flush hidden door pull, satin chrome finish, provide CRL concealed hold open door doser - concealed in transom, concealed Soss hinges, satin chrome finish. Ensure veneer matches exactly to adjacent wall paneling. Consult with millworker as required. Coordinate locking mechanism with Canada Post guidelines.
Supplier: **Citywide Door and Hardware**

140.1 ELEVATOR LOBBY
270mm high custom wood #2 doors, with as per opening, on concealed Soss hinges with concealed closer. Recessed crash bar on interior side for finish similar to wood. Supplier to provide samples.
Supplier: **Citywide Door and Hardware**

140.2 CORRIDOR B
240mm high 45 min rated wood door & hollow metal frame, complete with vision lite as per architect's specifications, for wood veneer finish as per wall finishes plan, hardware to be Schlage Architectural Hardware, lever style pulls, S series model Jupiter, IN#026 (satin chrome), provide hinges self closer all in satin chrome finish, Electronic strike TBD as per architects specification.
Supplier: **Citywide Door and Hardware**

141.1 EAST VESTIBULE INTERIOR SIDE
Double glazed hi parting doors as per architect's specifications, hardware to be by Canadian builders Hardware, Blumcraft series 100 pulls, length as per elevation, satin chrome finish, back to back installation, provide hinges self closer in satin chrome finish.
Supplier: **Citywide Door and Hardware**

141.2 EAST VESTIBULE TO EXTERIOR
Double glazed automatic hi parting breakaway storefront door with sidelights as per architect's specification.
Supplier: **Citywide Door and Hardware**

142.1 RESIDENTIAL LOBBY
245mm high double glazed doors, as per architect's specifications, c/w exit hardware, electronic operator.
Supplier: **Citywide Door & Hardware**

142.2 WEST VESTIBULE
2745mm high frameless double glazed doors, as per architect's specifications, c/w exit hardware, electronic operator. Electronic strike as per architect's specification.
Supplier: **Citywide Door and Hardware**

143A FITNESS ROOM VFCU ACCESS AND STORAGE CLOSET
240mm high wood door & frame, type 1, with buver, hardware to be Schlage Architectural Hardware, lever style pulls, S Series model Jupiter, IN#026 (satin chrome), as per architect's specification, finish as per wall finishes plan.
Supplier: **Citywide Door and Hardware**

143B FITNESS ROOM VFCU ACCESS
240mm high custom millwork vertical fan coil unit access door with buver, hardware to be Schlage Architectural Hardware, lever style pulls, S series model Jupiter, IN#026 (satin chrome), as per architect's specification, finish as per wall finishes plan. Refer to detail # 43D2.4.1
Supplier: **Citywide Door and Hardware**

143C FITNESS ROOM VFCU ACCESS
240mm high custom millwork vertical fan coil unit access door with buver, hardware to be Schlage Architectural Hardware, lever style pulls, S series model Jupiter, IN#026 (satin chrome), as per architect's specification, finish as per wall finishes plan. Refer to detail # 43D2.4.1
Supplier: **Citywide Door and Hardware**

144 VESTIBULE
240mm high 90 min rated hollow metal door & frame, type A with no vision, for paint finish as per wall finishes plan, hardware to be Schlage Architectural Hardware, lever style pulls, S series model Jupiter, IN#026 (satin chrome), provide hinges, and concealed self closer all in satin chrome finish.
Supplier: **Citywide Door and Hardware**

145.2 RESIDENTIAL BIKE STORAGE
2440 mm high 45 min rated hollow core metal door, complete with vision lite as per architect's specifications, for paint finish as per wall finishes plan, hardware to be Schlage Architectural Hardware, lever style pulls, S series model Jupiter, IN#026 (satin chrome), provide hinges self closer all in satin chrome finish, Electronic strike TBD as per architect's specification.
Supplier: **Citywide Door and Hardware**

146A.8 MEN'S CHANGEROOM VESTIBULE
240mm high solid core wood door for wood veneer finish as per wall finishes plan, hardware to be Elmes full length pull #G999-01-130-P1925 (1830mm L), both sides, provide concealed self closer, strike plate, hinges, satin chrome finish.
Supplier: **Citywide door & hardware**

147 MEN'S CHANGEROOM WC
240mm high solid core wood door for wood finish as per wall finishes plan, hardware to be Elmes full length pull #G999-01-130-P1925 (1830mm L), provide self closer, strike plate, hinges, privacy set (inside only), satin chrome finish, refer to elevation.
Supplier: **Citywide door & hardware**

148 MEN'S WC BF
240mm high solid core wood door for wood finish as per wall finishes plan, hardware to be Elmes full length pull #G999-01-130-P1925 (1830mm L), provide self closer, strike plate, hinges, privacy set (inside only), satin chrome finish, refer to elevation.
Supplier: **Citywide door & hardware**

148.1 MEN'S CHANGEROOM TO WHIRLPOOL SPA
240mm high frameless frosted glazed door, thickness as required, tempered as required, hardware to be Elmes full length pull #G999-01-130-P1925 (1830mm L), to match elevation, back to back installation, provide patch fittings, pivot hinges all in satin chrome finish, rubber striping to be used as required.
Contact: **City Wide Door & Hardware**

148.2 WOMEN'S CHANGEROOM TO WHIRLPOOL SPA
240mm high frameless frosted glazed door, thickness as required, tempered as required, hardware to be Elmes full length pull #G999-01-130-P1925 (1830mm L), to match elevation, back to back installation, provide patch fittings, pivot hinges all in satin chrome finish, rubber striping to be used as required.
Contact: **City Wide Door & Hardware**

150 JANITOR CLOSET IN WOMEN'S CHANGEROOM
240mm high hollow core metal door for paint finish as per wall finishes plan, hardware to be lever style handles by Schlage, AL-Series Jupiter, satin chrome finish, provide self closer, strike plate, hinges, satin chrome finish.

151A/B WOMEN'S CHANGEROOM VESTIBULE
240mm high solid core wood door for wood veneer finish as per wall finishes plan, hardware to be Elmes full length pull #G999-01-130-P1925 (1830mm L), both sides, provide concealed self closer, strike plate, hinges, satin chrome finish.
Supplier: **Citywide door & hardware**

152 WOMEN'S CHANGEROOM WC
240mm high solid core wood door for wood finish as per wall finishes plan, hardware to be Elmes full length pull #G999-01-130-P1925 (1830mm L), provide self closer, strike plate, hinges, privacy set (inside only), satin chrome finish, refer to elevation.
Supplier: **Citywide door & hardware**

153 WOMEN'S CHANGEROOM BF WC
240mm high solid core wood door for wood finish as per wall finishes plan, hardware to be Elmes full length pull #G999-01-130-P1925 (1830mm L), provide self closer, strike plate, hinges, privacy set (inside only), satin chrome finish, refer to elevation.
Supplier: **Citywide door & hardware**

154 CORRIDOR D TO FITNESS AREA
2700mm high frameless double clear glazed door, thickness as req'd, tempered as req'd, hardware to be lever style handles by Schlage, s-series Jupiter, satin chrome finish, lockset, provide concealed self closer, strike plate, cover assist (H&L), concealed automatic operator, refer to elevations.
Supplier: **Citywide door & hardware**

156 BARRIER FREE WC
240mm high solid core wood door for wood finish as per wall finishes plan, hardware to be Elmes full length pull #G999-01-130-P1925 (1830mm L) (corridor side only), provide self closer, strike plate, hinges, privacy set (inside only), satin chrome finish, refer to elevation.
Supplier: **Citywide door & hardware**

157 BARRIER FREE WC
240mm high solid core wood door for wood finish as per wall finishes plan, hardware to be Elmes full length pull #G999-01-130-P1925 (1830mm L) (corridor side only), provide self closer, strike plate, hinges, privacy set (inside only), satin chrome finish, refer to elevation.
Supplier: **Citywide door & hardware**

158 THEATRE
2440 mm high solid core wood door complete with flush concealed Soss hinges and provide concealed self closer, strike plate hardware to be Elmes full length pull # G999-01-130-P1925 (1830mm L), both sides, refer to elevation.
Supplier: **Citywide door & hardware**

158A THEATRE VFCU PANEL
240mm high solid millwork vertical fan coil unit access frameless removable panel with buver. Clip system to be similar to spacer or a suitable alternate. Button Fix 2 supplied by Lee Valley. Finish as per wall finishes plan. Refer to detail # 43D2.4.1
Supplier: **Millworker**

158C THEATRE EQUIPMENT ROOM
240mm high solid core wood door for paint finish as per wall finishes plan, hardware to be lever style handles by Schlage, s-series Jupiter, satin chrome finish, lockset, provide self closer, strike plate, hinges, satin chrome finish.
Supplier: **Citywide door & hardware**

159 CORRIDOR D ELECTRICAL CLOSET
240mm high 90 min rated wood door for wood finish per wall finishes plan, hardware to be lever style handles by Schlage, s-series Jupiter, satin chrome finish, lockset, provide self closer, strike plate, hinges, satin chrome finish. Install flush with corridor walls.
Supplier: **Citywide door & hardware**

160.1 CORRIDOR C TO CORRIDOR A
240mm high 45 min rated wood door & hollow metal frame, complete with vision lite as per architect's specifications, for wood veneer finish as per wall finishes plan, hardware to be Schlage Architectural Hardware, lever style pulls, S series model Jupiter, IN#026 (satin chrome), provide hinges self closer all in satin chrome finish, Electronic strike TBD as per architect's specification.
Supplier: **Citywide Door and Hardware**

160.2 PARTY ROOM AMENITY ENTRANCE
2700mm high Type H frameless clear glazed pivot door with side lite, thickness as req'd, tempered as req'd, hardware to be lever style handles by Schlage, s-series Jupiter, satin chrome finish, lockset, provide concealed self closer, strike plate, cover assist, refer to elevations. Concealed strike H handle. Glazing film by designer.
Supplier: **Citywide door & hardware**

161.1 CORRIDOR TO DINING ROOM
240mm high solid core wood door for wood #1, hardware to be Elmes full length pull # G999-01-130-P1925 (1830mm L), both sides, satin chrome finish, provide concealed self closer, strike plate, hinges, satin chrome finish with no vision type A
Supplier: **Citywide door & hardware**

161.2 KITCHEN TO DINING ROOM
240mm high solid core wood door for wood #1, hardware to be Elmes full length pull # G999-01-130-P1925 (1830mm L), both sides, satin chrome finish, provide concealed self closer, strike plate, hinges, satin chrome finish with no vision type A
Supplier: **Citywide door & hardware**

161A DINING ROOM VFCU PANEL
240mm high custom millwork vertical fan coil unit access frameless removable panel with buver. Clip system to be similar to spacer or a suitable alternate. Button Fix 2 supplied by Lee Valley. Finish as per wall finishes plan. Refer to detail # 43D2.4.1
Supplier: **Millworker**

162 AMENITY KITCHENETTE
240mm high solid core wood door for wood #1, hardware to be Elmes full length pull # G999-01-130-P1925 (1830mm L), both sides, satin chrome finish, provide concealed self closer, strike plate, hinges, satin chrome finish.
Supplier: **Citywide door & hardware**

162A AMENITY KITCHENETTE VFCU
240mm high wood door & frame, type T with buver, as per architect's specification finish as per wall finishes plan.
Supplier: **Citywide Door and Hardware**

163 AMENITY - PARTY ROOM EXIT TO TERRACE
2875 mm high, as per architectural specification.

163A AMENITY PARTY ROOM VFCU
240mm high wood door & frame, type T with buver, as per architect's specification finish as per wall finishes plan.
Supplier: **Citywide Door and Hardware**

163B AMENITY PARTY CLOSET
240mm high wood door & frame, as per architect's specification finish as per wall finishes plan.
Supplier: **Citywide Door and Hardware**

164 PROPERTY MANAGEMENT OFFICE
240mm high frameless clear glazed door, thickness as req'd, tempered as req'd, privacy film to be applied to glass- design to be determined by designer, hardware to be lever style handles by Schlage, s-series Jupiter, satin chrome finish, lockset, provide concealed self closer, strike plate, full chrome finish, refer to elevations.
Supplier: **Citywide door & hardware**

166.1 MANAGEMENT OFFICE
240mm solid core wood door for paint finish as per wall finishes plan, hardware to be lever style handles by Schlage, s-series Jupiter, satin chrome finish, lockset with privacy from inside, provide self closer, strike plate, hinges, satin chrome finish, refer to elevation.
Supplier: **Citywide door & hardware**

166.2 PROPERTY MANAGEMENT MECH. CL.
240mm high hollow core metal door for paint finish as per wall finishes plan, hardware to be lever style handles by Schlage, s-series Jupiter, satin chrome finish, lockset, provide self closer, strike plate, hinges, satin chrome finish.
Supplier: **Citywide door & hardware**

167 KITCHEN COPY
240mm solid core wood door for paint finish as per wall finishes plan, hardware to be lever style handles by Schlage, s-series Jupiter, satin chrome finish, lockset, provide self closer, strike plate, hinges, satin chrome finish, refer to elevation.
Supplier: **Citywide door & hardware**

168 CAC ROOM
2440mm high 180 degree opening 90min rated solid core slab wood pivot door for wood#2, concealed frame for wood #2, wood to be treated for fire rating, hardware to be Schlage Architectural Hardware, lever style pulls, S Series model Jupiter, IN #026 (satin chrome), provide concealed Soss hinges, self closer all in satin chrome finish, refer to elevations.
Supplier: **Citywide door & hardware**


169 PARCEL ROOM
2440 mm high solid core slab wood door for wood#2, concealed frame for wood #2 wood to be treated for fire rating, hardware to be Schlage Architectural Hardware, lever style pulls, S Series model Jupiter, IN #026 (satin chrome), provide concealed Soss hinges, self closer all in satin chrome finish, electronic strike TBD as per architect's specifications, refer to elevations.
Supplier: **Citywide door & hardware**

172.2 GROUND FLOOR RESIDENTIAL GARAGE
2440mm high 90 min rated hollow core metal door for paint finish as per wall finishes plan, hardware to be lever style handles by Schlage, s-series Jupiter, satin chrome finish, lockset with privacy from inside, provide self closer, strike plate, hinges, satin chrome finish, refer to elevations.
Supplier: **Citywide door & hardware**

173.1 RESIDENTIAL MOVING
240mm high 45 min rated hollow core metal door for paint finish as per wall finishes plan, hardware to be lever style handles by Schlage, s-series Jupiter, satin chrome finish, provide self closer, strike plate, hinges, satin chrome finish.
Supplier: **Citywide door & hardware**

935 9th FLOOR BF WC
215mm high solid core wood door for paint finish as per wall finishes plan, hardware to be Elmes full length pull #G999-01-130-P1925 (1830mm L), provide self closer, strike plate, hinges, privacy set (inside only), satin chrome finish, refer to elevation.
Supplier: **Citywide door & hardware**

LIGHTING AND ELECTRICAL LEGEND

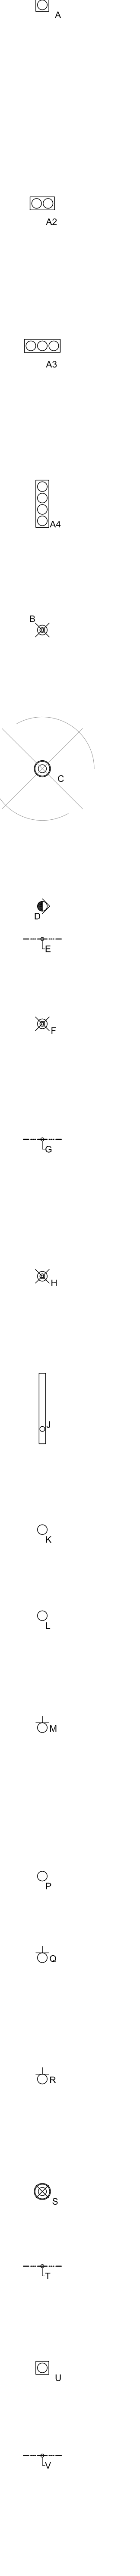

TYPE A (Throughout)
Recessed rectangular directional down light fixture
Eurofase TL7 Triness Multiple Recessed LED w/ driver
Size: 4" x 4"
Lamp: 3 x 9w LED, warm white 3000K
Finish: White
Specification: # TE1211LED-02
Substrate housing as required. Plaster kit as required.
Refer to RCP for location.
Supplier: **Litomedo**
Contact:

TYPE B (Lobby, Beside Fireplace)
Pendant
Vibra 58mm one light pendant
Size: 38.25" x 1" dia x 6-1/4" canopy
Finish: 1x3w LED
Finish: Black
Specification: SBR 9020
Substrate housing as required.
Refer to RCP for location.

TYPE C (Lobby Lounge)
Concentric ring chandelier
Paul Lockach Halo Chandelier - 3 Rings
Ball and Ball
47" dia x 34" x 12" Mesh Level Trim**
Blackened Steel Finish
Drop height TBD on site.
Supplier: **Light Form**

TYPE D (Throughout)
Same as Type A, to be aimed and adjusted on site with designer.

TYPE E (Cove Lighting Throughout)
Installed Pro 2 High Output Tape Light LED-TX2430-S-WT
4w per foot, 30' CB
Supplier: **WAC Lighting**

TYPE F (Amenity, Bar)
Pendant fixture
Vibra Rhythm 2113-14 by Ash Lery
40w, 8W LED Strip, 116W total
Fin: 14 (Black)
Supplier: **Lightform**

TYPE G (Throughout, Millwork)
Under cabinet light
Fosca Slimline LED w flat milky lens
Model #SL1530
15W, 3000K
c/w SL-8-socket, connectors and power supply as required.
Refer to RCP and elevations for lengths.
Supplier: **Lightform**

TYPE H (Dining Room Wall Niches)
Pendant Light
Delightful Brubeck pendant light.
Finish to match type H
Refer to RCP and elevations for qty and location.
Supplier: **Studio112**

TYPE J (Dining Room)
Pendant light
Delightful Cobran Suspension Light: Black Matte exterior, Gold powder interior, 2x G9 Halogen Bulbs
per site (Confirm compatible LED replacement), Cord length TBD on site, 1000mm x 150mm Dia
Qty per RCP/Elevation.
Supplier: **Studio112**

TYPE K (Fitness Area, Millwork)
Recessed Adjustable Downlight
Eurofase TE111LED
01 Black/Black Trim
14W LED
Refer to RCP for location.
Supplier: **Litomedo**

TYPE L (Spa)
Recessed Shower Light
Contract Lighting A24505
Size: 4" dia
Lamp: 1 x20w compact fluorescent
Finish: shower trim with frosted lens, brushed nickel
Refer to RCP for qty and location.
Supplier: **Studio112**

TYPE M (Barrier Free Washroom - grd and 9th floor)
Surface Mounted Light
Eurofase Lup 3151
Size: 18"
Finish: 2W LED, 3000K
Chrome structure, matte white diffuser
Refer to RCP for qty and location.
Supplier: **Studio112**

TYPE N
N/A

TYPE P (Showers)
Recessed 2 Inch Adjustable Downlight
Elin - 3 in Round, Flanged Bevel Shower trim.
Finish: White
Supplier: **Litomedo**

TYPE Q (Theatre)
Wall Scoop
Skoob Vertical Scoop
4" x 4" length
White/Blackened Steel
3000K Warm LED light
Refer to RCP and Elevations for location.
Supplier: **Litomedo**

TYPE R (Suite Entry)
Wall Scoop
Eurofase Apt 2-Light Wall Scoop
Matt Black finish for body with clear acrylic for shade
2x1W LED light
Refer to RCP and Elevations for location.
Supplier: **Litomedo**

TYPE S (Typical Corridors)
Surface Mounted Fixture
Eurofase Soss 3036-WH
LED 22.5W, 3000K 22W
Supplier: **Litomedo**

TYPE T (Party Room - TV unit)
Low Profile Recessed Display Light
MF Lighting L14
2.5W, 3000K, narrow flood
Black anodized aluminum
Supplier: **Studio112**

TYPE U (Parking Levels)
Eurofase Bass
1250-D14-WH-H-8L-K-BLK
4W LED, 3000K
Refer to RCP for locations.
Supplier: **Litomedo**

TYPE V (Lobby, Between Wood Flx)
Upr Recessed LED
LUMI-REC-019
7W LED, 3000K
58mm W x Length as per RCP - to align with wood flx.
Refer to RCP for locations.
Supplier: **Zaneen**

TYPE W (Elevator Lobby)

TYPE X (Lobby-over-congrace desk)
Pendant Light
Vibra 58mm One
Black carbon fiber for hanging lights
and ceiling plate
7x 3w LED, 3000K
Refer to RCP for locations.
Supplier: **Lightform**

Duplex receptacle outlet (for specialty usage in addition to Electrical Drawings)

Floor mounted duplex receptacle outlet (for specialty usage in addition to Electrical Drawings)

Communication for voice (phone) outlet (for specialty usage in addition to Electrical Drawings)

Communication for fax outlet (for specialty usage in addition to Electrical Drawings)

Communication for data (internet) outlet (for specialty usage in addition to Electrical Drawings)

Powerline as noted (for specialty usage in addition to Electrical Drawings)

Cable / satellite TV outlet
Refer to RCP for location.

DO NOT SCALE DRAWINGS.

CONTRACTOR MUST VERIFY ALL DRAWINGS, DIMENSIONS, DETAILS AND SPECIFICATIONS, AND REPORT ANY DISCREPANCIES TO UNION 31 INC. BEFORE PROCEEDING WITH WORK. MATERIALS MAY NOT BE SUBSTITUTED WITHOUT WRITTEN APPROVAL FROM UNION 31 INC.

ALL DRAWINGS AND SPECIFICATIONS ARE INSTRUMENTS OF SERVICE AND THE PROPERTY OF UNION 31 INC. WHICH MUST BE RETURNED AT THE COMPLETION OF THE WORK.

PRINTED: 26-Aug-15

NO.	DATE	COMMENTS	INI
13	24 AUG / 15	RE- ISSUED FOR DRYWALL TENDER	CB
12	21 AUG / 15	ISSUED FOR TRIM CARPENTRY AND DRYWALL	CB
11	20 AUG / 15	ISSUED FOR DRYWALL TENDER	CB
10	15 JUL / 15	ISSUED FOR TRIM CARPENTRY TENDER	CB
09	16 JUNE / 15	ISSUED FOR FINISH CARPENTRY	CB
07	02 JUNE / 15	LIGHTING TENDER ADDENDUM#1	CB
03	06 MAR / 15	ISSUED FOR TILE TENDER	AP
02	26 JAN / 15	ISSUED FOR TILE TENDER	AP
01	22 AUG / 14	ISSUED FOR PERMIT	AP
NO.	DATE	COMMENTS	INI

UNION31 INC.
183 BATHURST STREET, STE. 201
TORONTO, ON, M5T 2R7, CANADA
TEL: 416-597-1576 FAX: 416-597-2139

PROJECT NAME:
ALEXANDRA PARK MAIN BUILDING
BLOCK 11
ON, Canada

PROJECT NO.: 13-949

DRAWINGS:
DOOR SCHEDULE LIGHTING & ELECTRICAL LEGEND

DATE STARTED: 07 AUG / 13 DRAWING NO.:
SCALE: NTS ID
DRAWN BY: AP 0,0.2
APPROVED BY: KC