


DO NOT SCALE DRAWINGS.

CONTRACTOR MUST VERIFY ALL DRAWINGS, DIMENSIONS, DETAILS AND SPECIFICATIONS AND REPORT ANY DISCREPANCIES TO UNION 31 INC. BEFORE PROCEEDING WITH WORK. MATERIALS MAY NOT BE SUBSTITUTED WITHOUT WRITTEN APPROVAL FROM UNION 31 INC.

ALL DRAWINGS AND SPECIFICATIONS ARE INSTRUMENTS OF SERVICE AND THE PROPERTY OF UNION 31 INC. WHICH MUST BE RETURNED AT THE COMPLETION OF THE WORK.

PRINTED: 3-04-15

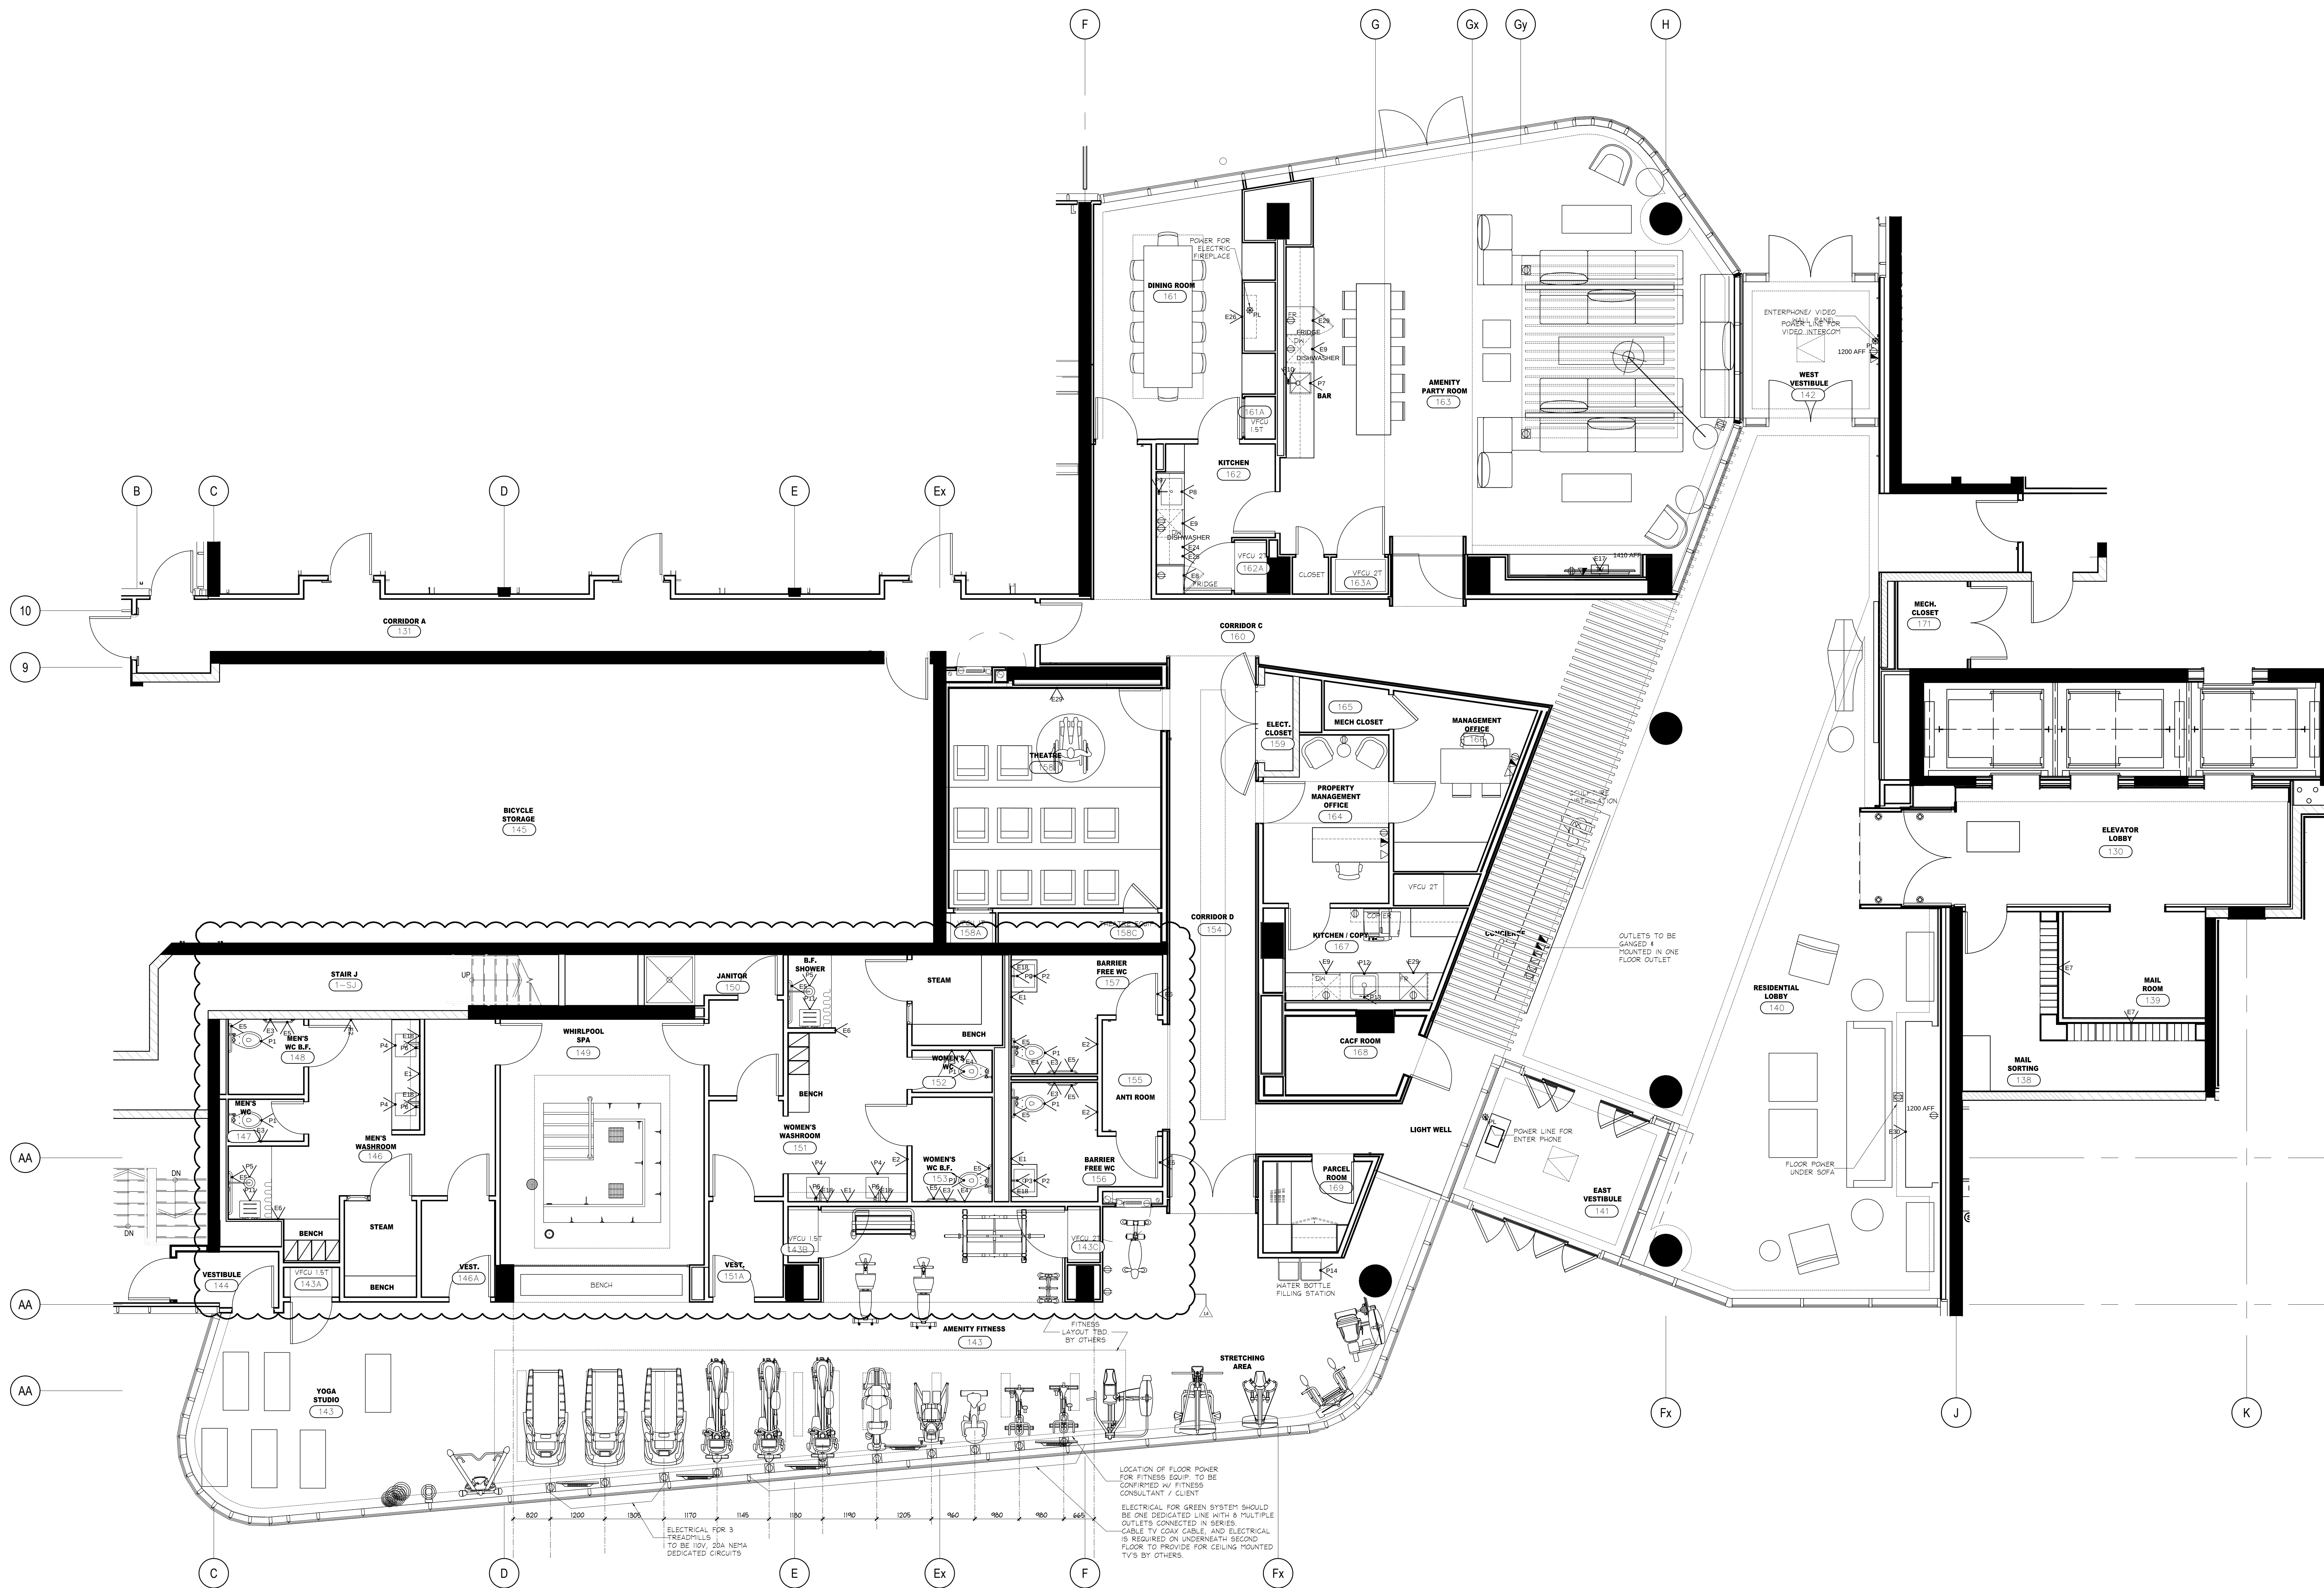

1 FURNITURE & POWER PLAN
GROUND FLOOR
SCALE: 1:50

14	8 SEPT / 15	ISSUED FOR TRIM CARPENTRY	CB
13	24 AUG / 15	ADDENDUM 2 SITE INSTRUCTION #2	CB
12	24 AUG / 15	RE: ISSUED FOR DRYWALL TENDER	CB
11	20 AUG / 15	ISSUED FOR DRYWALL TENDER	CB
10	15 JUL / 15	ISSUED FOR TRIM CARPENTRY TENDER	CB
09	15 JUNE / 15	ISSUED FOR FINISH CARPENTRY	CB
08	11 JUNE / 15	SITE INSTRUCTION #1	CB
07	06 MAR / 15	ISSUED FOR TILE TENDER	AP
06	26 JAN / 15	ISSUED FOR TENDER	AP
05	22 AUG / 14	ISSUED FOR PERMIT	AP
NO.	DATE	COMMENTS	INI

UNION 31

UNION31 INC.
183 BATHURST STREET, STE. 201
TORONTO, ON, M5T 2R7, CANADA
TEL: 416-597-1576 FAX: 416-597-2139

PROJECT NAME:		ALEXANDRA PARK MAIN BUILDING	
PROJECT NO.:		13-949	
DRAWINGS:		GROUND FLOOR FURNITURE & POWER PLAN	
DATE STARTED:		07 AUG / 13	DRAWING NO.:
SCALE:		1" = 50'	ID
DRAWN BY:		AP	1.1.2
APPROVED BY:		KC	