



DO NOT SCALE DRAWINGS.

CONTRACTOR MUST VERIFY ALL DRAWINGS, DIMENSIONS, DETAILS AND SPECIFICATIONS, AND REPORT ANY DISCREPANCIES TO UNICOR 31 INC. BEFORE PROCEEDING WITH WORK. MATERIALS MAY NOT BE SUBSTITUTED WITHOUT WRITTEN APPROVAL FROM UNICOR 31 INC. ALL DRAWINGS AND SPECIFICATIONS ARE INSTRUMENTS OF SERVICE AND THE PROPERTY OF UNICOR 31 INC. WHICH MUST BE RETURNED AT THE COMPLETION OF THE WORK.


PRINTED: 20-Jan-16

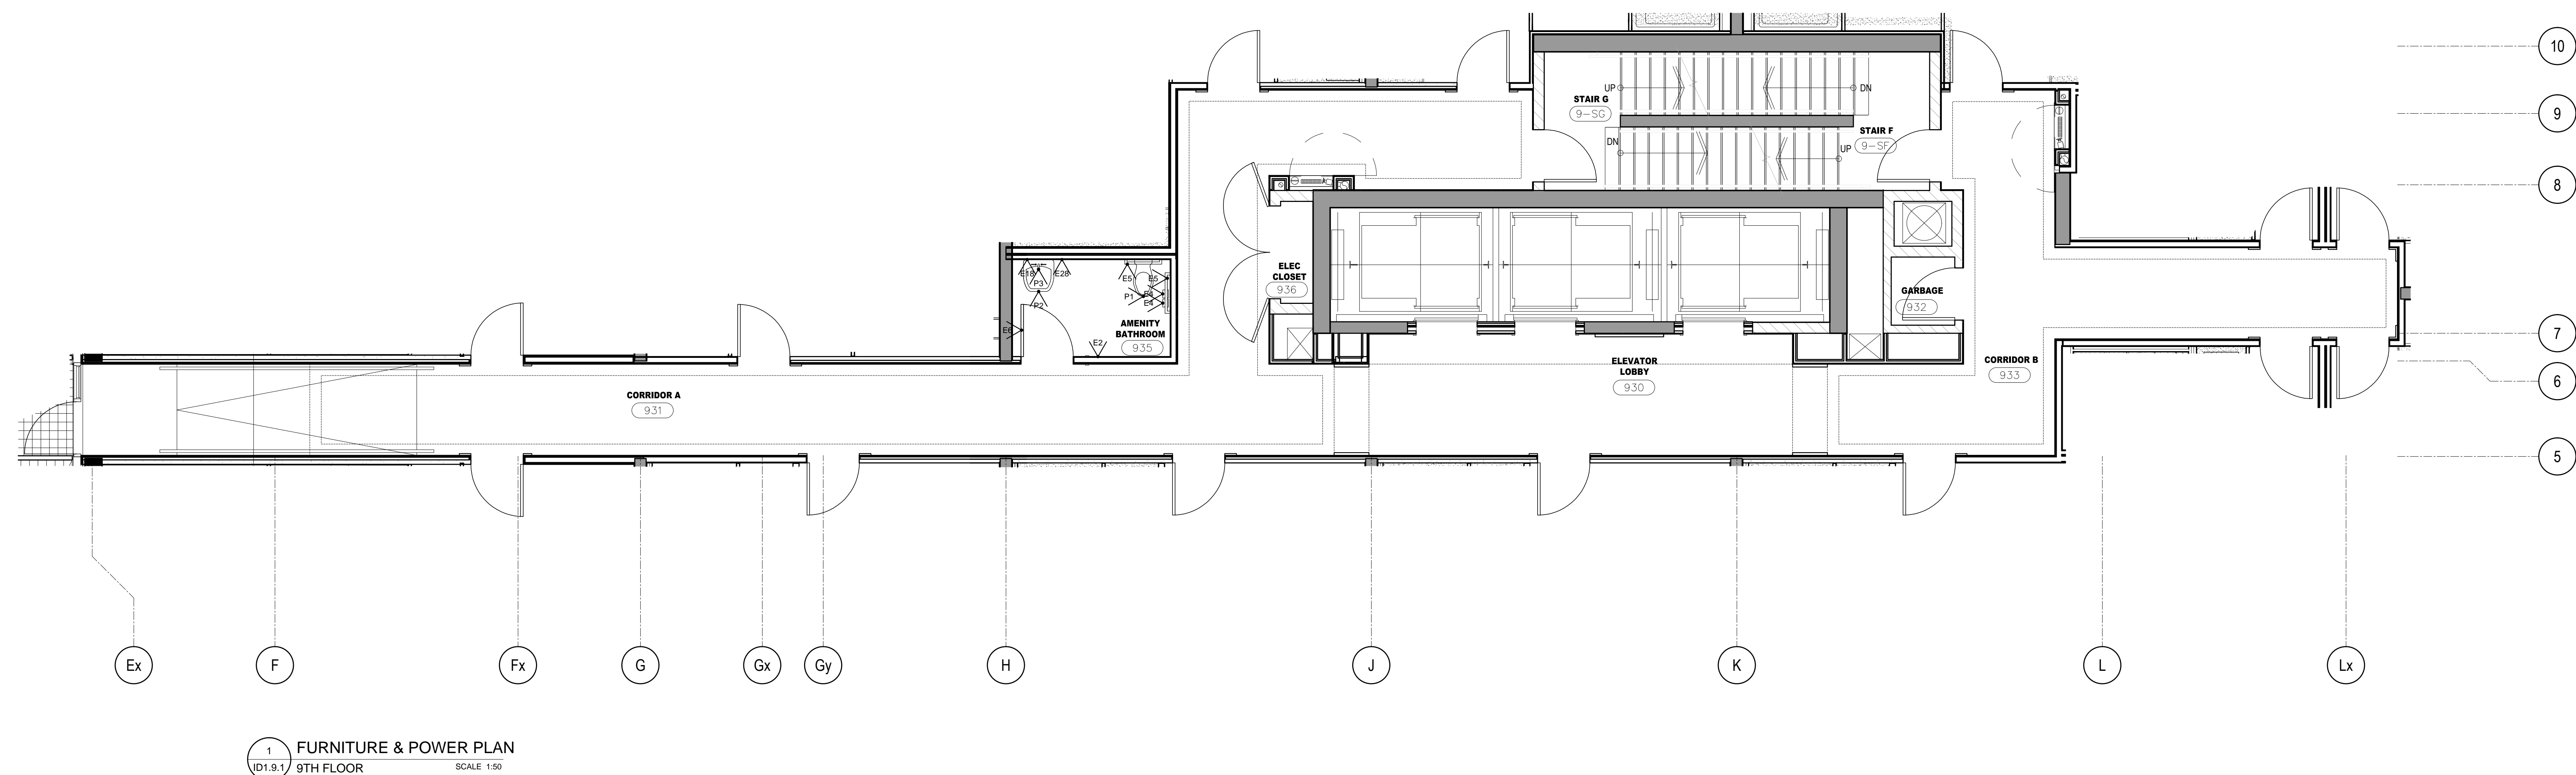

1. FURNITURE & POWER PLAN  
ID19.1 9TH FLOOR SCALE 1:50

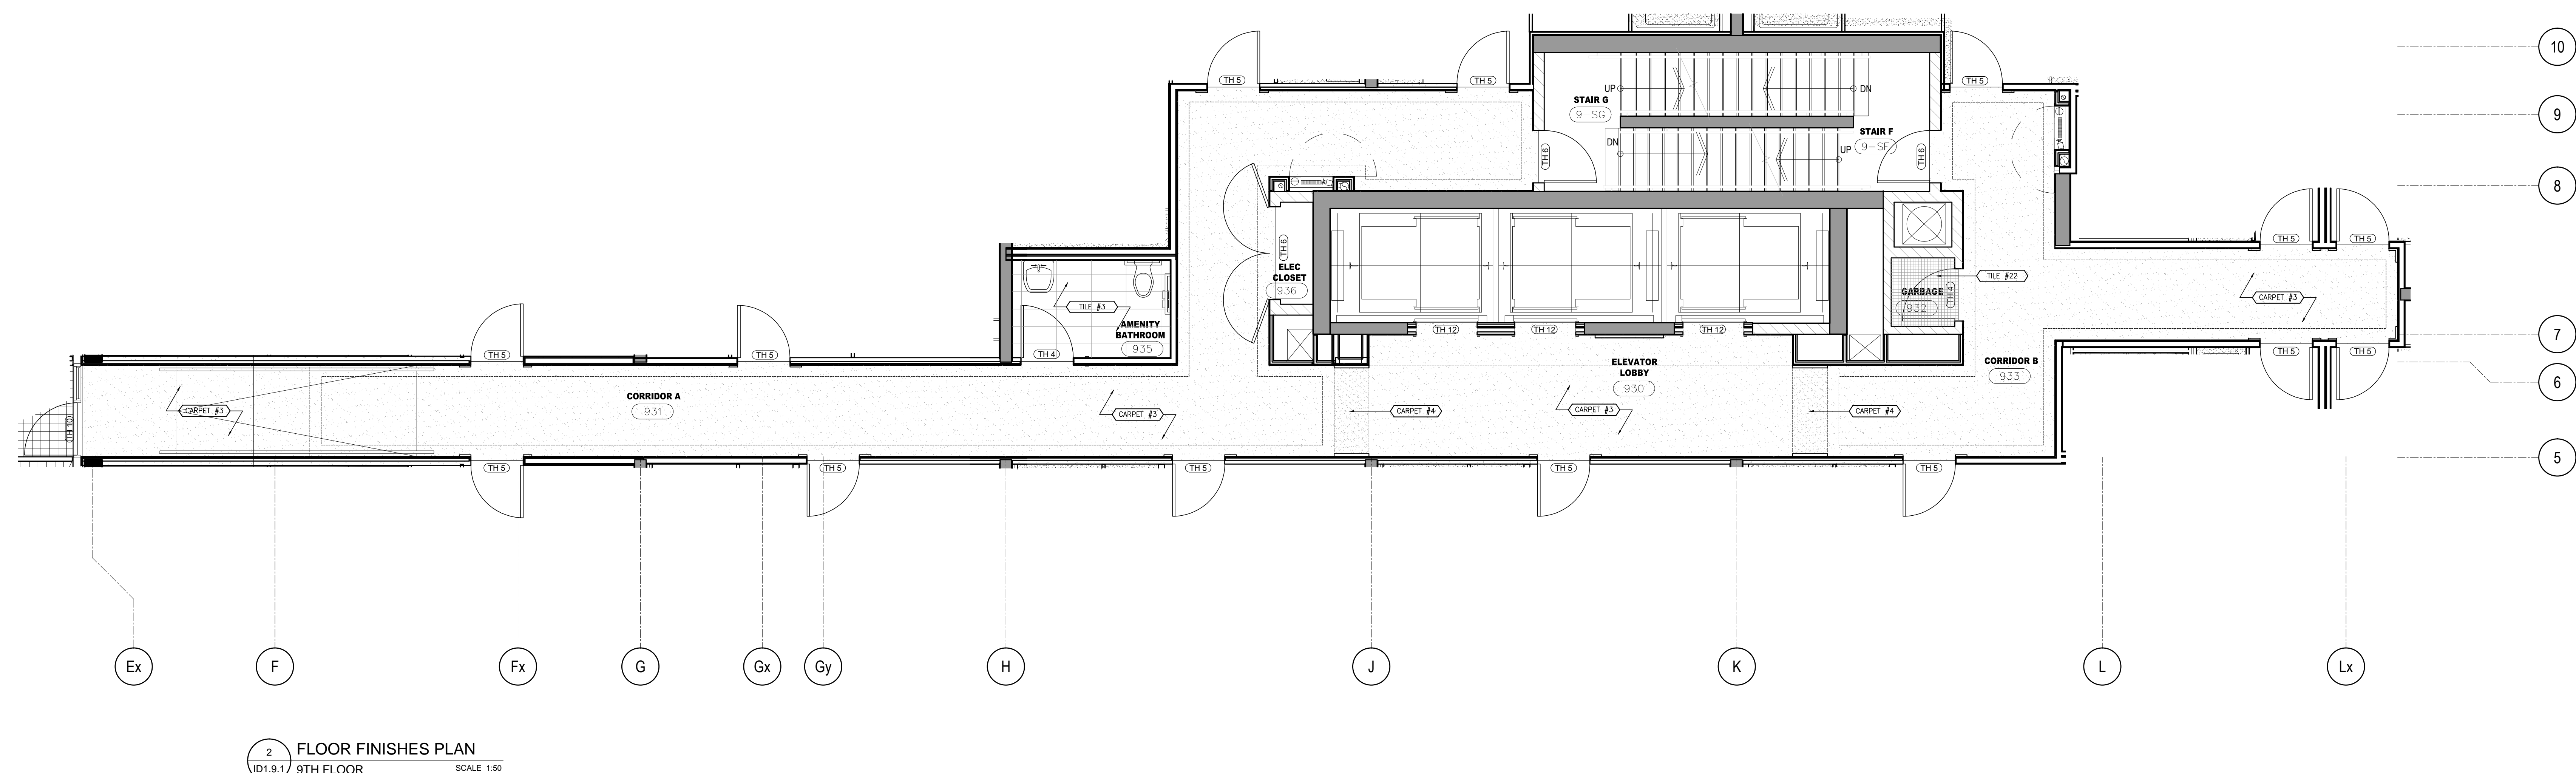

2. FLOOR FINISHES PLAN  
ID19.1 9TH FLOOR SCALE 1:50

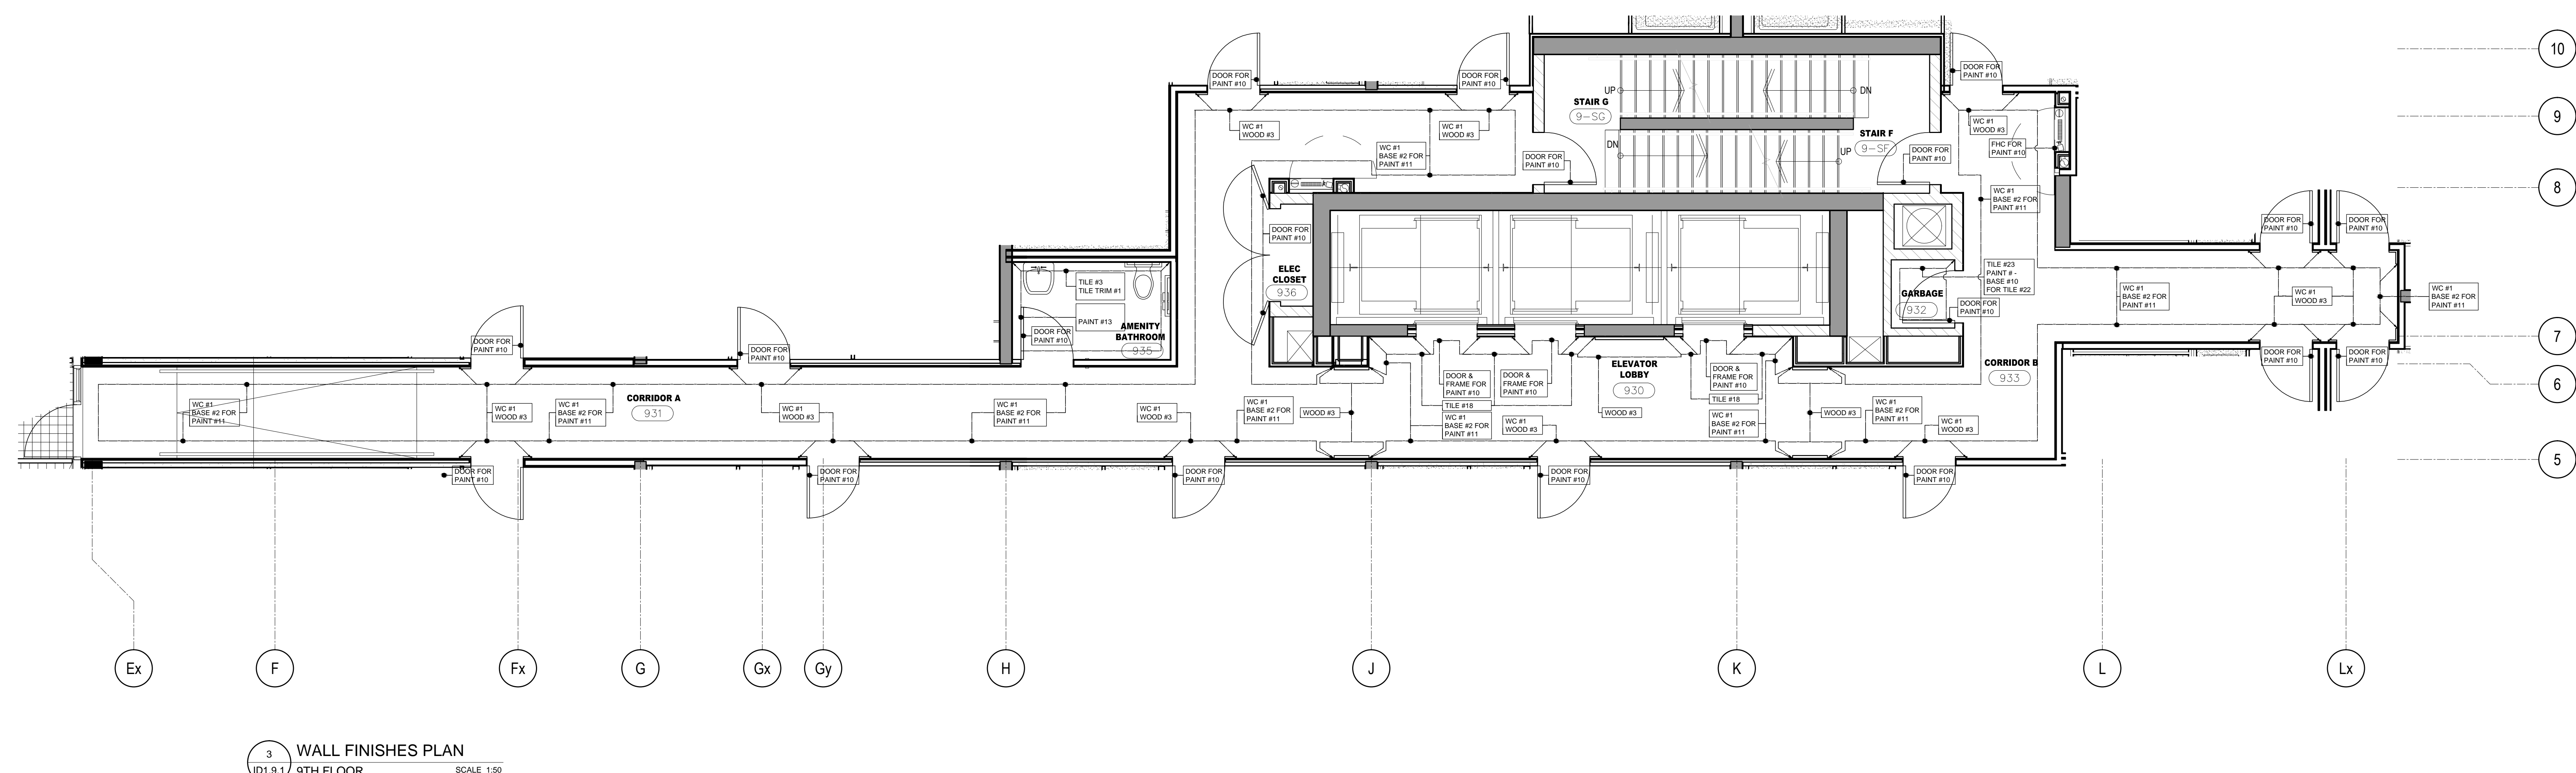

3. WALL FINISHES PLAN  
ID19.1 9TH FLOOR SCALE 1:50

NO.	DATE	COMMENTS	INI
16	21 JAN / 16	ISSUED FOR PAINT / WALLPAPER TENDER	CB
14	8 SEPT / 15	ISSUED FOR TRIM CARPENTRY	CB
		ADDITIONAL SITE INSTRUCTION #2	CB
13	24 AUG / 15	RE- ISSUED FOR DRYWALL TENDER	CB
11	20 AUG / 15	ISSUED FOR DRYWALL TENDER	CB
10	15 JULY / 15	ISSUED FOR TRIM CARPENTRY TENDER	CB
09	16 JUNE / 15	ISSUED FOR FINISH CARPENTRY	CB
03	06 MAR / 15	ISSUED FOR TILE TENDER	AP
02	26 JAN / 15	ISSUED FOR TENDER	AP
01	22 AUG / 14	ISSUED FOR PERMIT	AP

**UNICOR 31**

**UNICOR 31 INC.**  
183 BATHURST STREET, STE. 201  
TORONTO, ON, M5T 2R7, CANADA  
TEL: 416-597-1576 FAX: 416-597-2139

PROJECT NAME: <b>ALEXANDRA PARK MAIN BUILDING</b>	
BLOCK 11 ON, Canada	
PROJECT NO.:	13-949
DRAWINGS:	9TH FLOOR FURNITURE & POWER PLAN FLOOR FINISHES PLAN & WALL FINISHES PLAN
DATE STARTED:	07 AUG / 13
SCALE:	1 : 50
DRAWN BY:	AP
APPROVED BY:	KC
DRAWING NO.:	<b>ID</b>
	<b>1.9.1</b>