



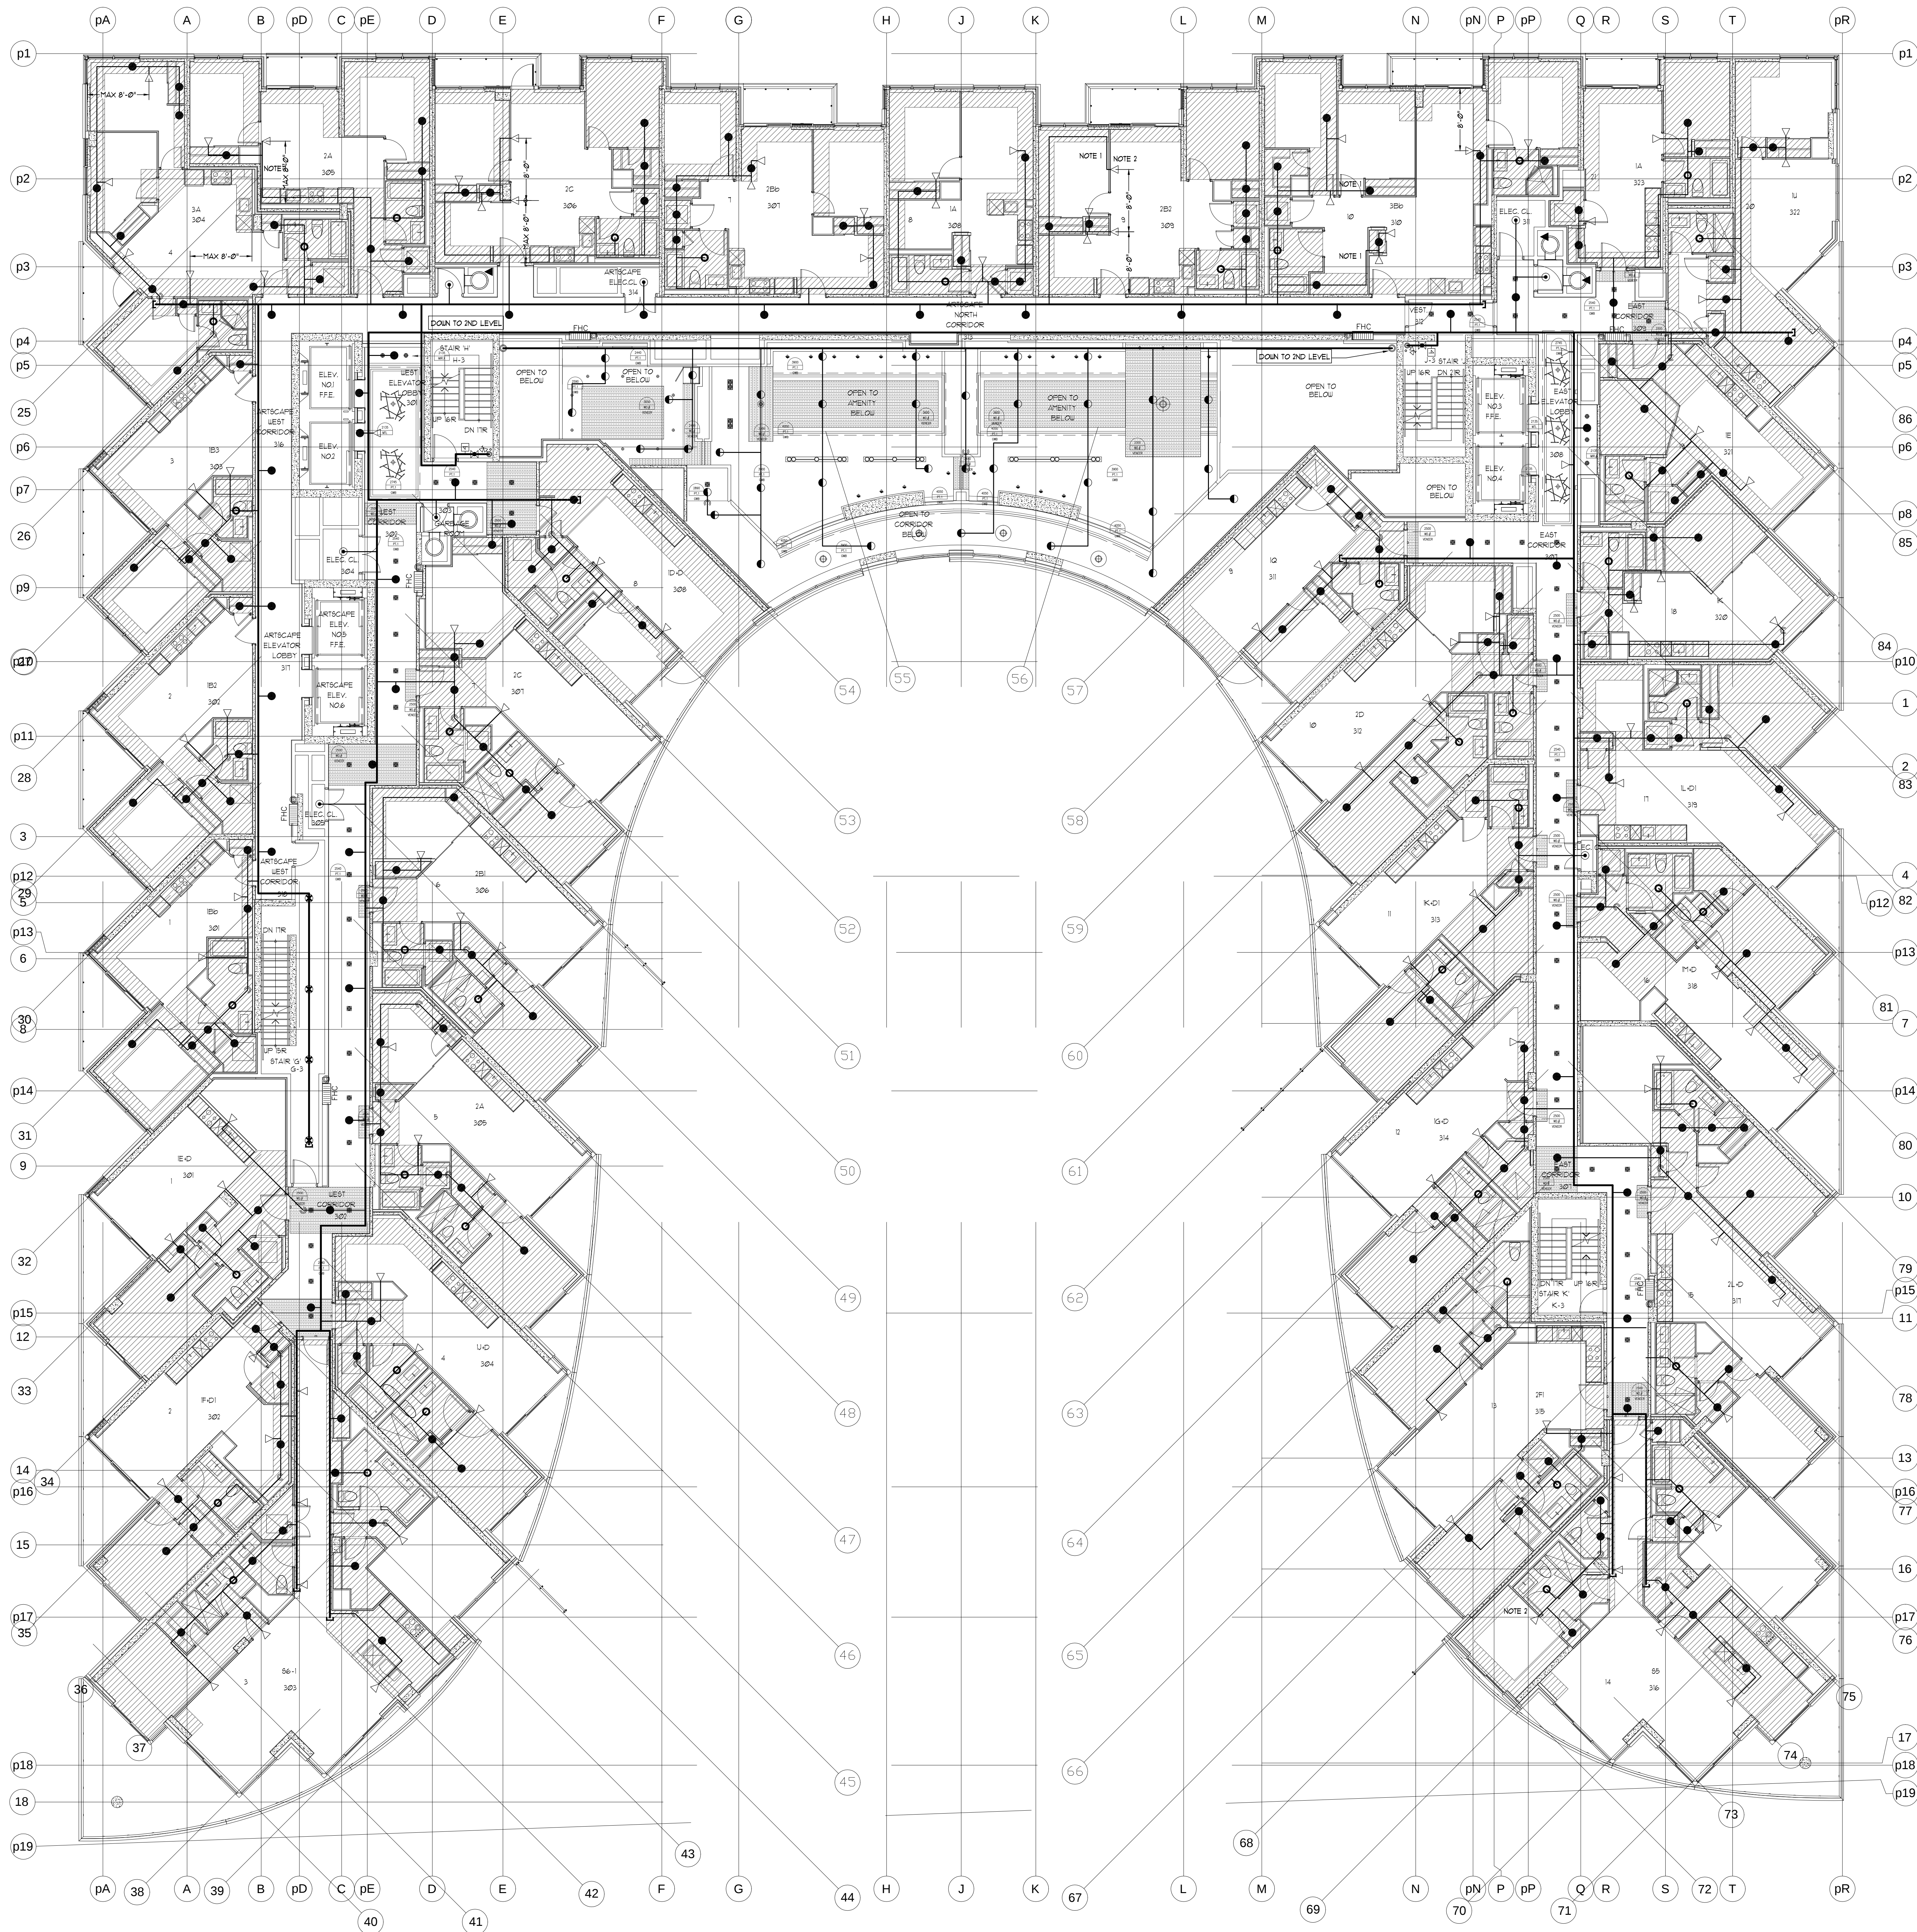

3RD FLOOR SPRINKLER LAYOUT
SCALE: 1/8"=1'-0"

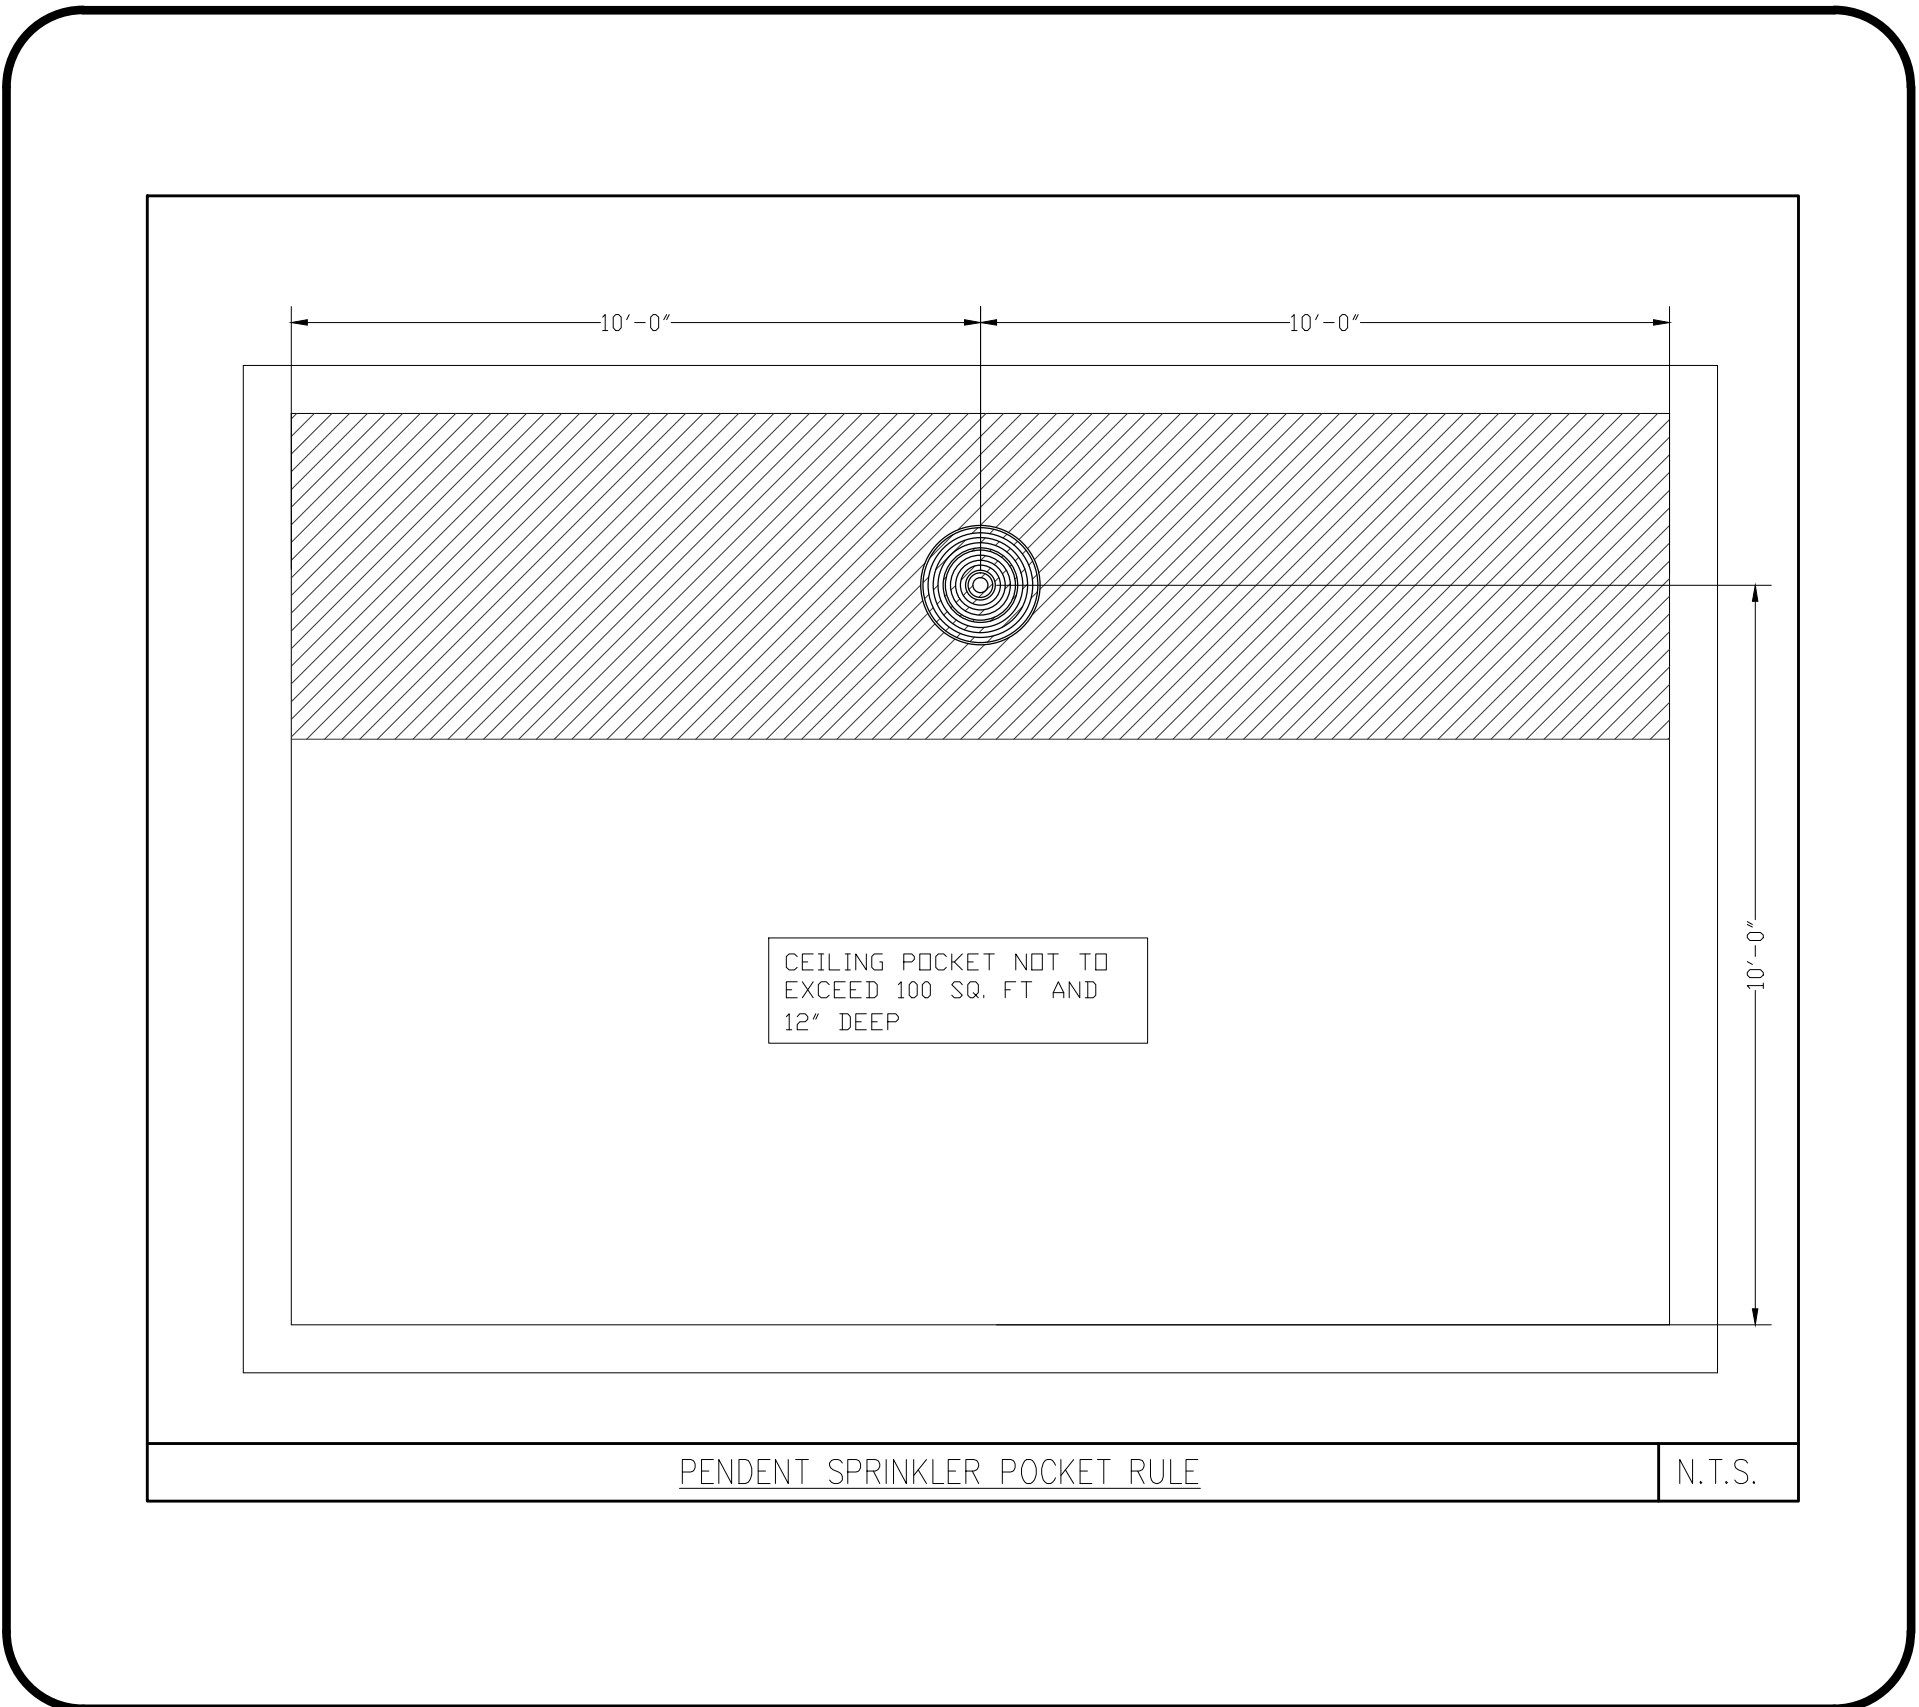

NOTES - RESIDENTIAL SIDEWALL SPRINKLERS:

1. MAXIMUM COVERAGE FOR RESIDENTIAL SIDEWALL SPRINKLERS NOT TO EXCEED 16' X 18'.
2. MINIMUM DISTANCE BETWEEN SPRINKLERS TO BE 8'-0".
3. MAXIMUM DISTANCE FROM ANY SIDE WALL TO SPRINKLER NOT TO EXCEED 8'-0".
4. SIDEWALL SPRINKLERS SHALL BE LOCATED AT LEAST 5'-0" FROM OBSTRUCTIONS SUCH AS CEILING FANS AND LIGHT FIXTURES.
5. SEE OBSTRUCTION TABLE ON DRAWING SP1.

NOTES - RESIDENTIAL PENDENT SPRINKLERS:

1. MAXIMUM COVERAGE FOR RESIDENTIAL PENDENT SPRINKLERS NOT TO EXCEED 17'1" FT.
2. MINIMUM DISTANCE BETWEEN SPRINKLERS TO BE 8'-0".
3. MAXIMUM DISTANCE FROM ANY SIDE WALL TO SPRINKLER NOT TO EXCEED 10'-0".
4. PENDENT SPRINKLERS SHALL BE LOCATED AT LEAST 3'-0" FROM OBSTRUCTIONS SUCH AS CEILING FANS AND LIGHT FIXTURES.
5. SEE OBSTRUCTION TABLE ON DRAWING SP1.

REVISIONS	
1.0	ISSUED FOR TENDER 10/15/15

NOTES	
-------	--

SPRINKLER LEGEND	
1/2" 165°F SC QR BRASS UPRIGHT SPRINKLER K= 5.6	00
1/2" 165°F SC QR CONCEALED PENDENT SPRINKLER K= 5.6 LH	00
1/2" 165°F SC SR BRASS UPRIGHT SPRINKLER K= 5.6 OH	00
VIKING MODEL VK457 FREEDOM RESIDENTIAL CONCEALED PENDENT SPRINKLER C/W WHITE 3-5/16" COVER PLATE K=4.9 165°F	00
VIKING MODEL VK457 FREEDOM RESIDENTIAL CONCEALED PENDENT SPRINKLER C/W WHITE 3-5/16" COVER PLATE K=4.9 165°F (ANTICORROSION RESISTANT COATING)	00
VIKING MODEL VK480 FREEDOM RESIDENTIAL HORIZONTAL WHITE SIDEWALL SPRINKLER C/W WHITE ESCUTCHEON PLATE 1/2" K=4.0 165°F 8" DEFLECTOR U.N.O. (MAXIMUM COVERAGE 16'X18' U.N.O.)	00
1/2" 165°F SC SR SIDEWALL SPRINKLER K= 5.6 OH	00
FIRE HOSE CABINET SEE DETAIL SHEET SP1	00

TRIDEL
BUILT FOR LIFE
4800 Dufferin St.
Toronto, Ontario M3H 5S9
(tel): 416-661-3290

MIRENDA
INCORPORATED
15171 Yonge Street Suite 202
Aurora Ontario L4G 1M1
(tel): 905-727-0092
(fax): 905-727-5517

NORTH	

STAMP	

PROJECT AQUAVISTA MERCHANTS WHARF TORONTO, ONTARIO	
DWG TITLE 3RD LEVEL SPRINKLER LAYOUT	
DATE 10/15/2015	PROJECT NO. 15-678
SCALE 1/8"=1'-0"	DWG NO. SP9
DWN BY JL	ISSUED FOR REVISION NO. 1.0
OF SP20	