

LEGEND : DRAWING SYMBOLS (CONT'D)		
SYMBOL	DESCRIPTION	
	CEILING MOUNTED SPEAKER	REFER TO CONSULTANT'S DRAWINGS FOR SPECIFICATIONS & LOCATIONS
	WALL MOUNTED EXIT LIGHT	REFER TO CONSULTANT'S DRAWINGS FOR SPECIFICATIONS & LOCATIONS
	CEILING MOUNTED EXIT LIGHT	REFER TO CONSULTANT'S DRAWINGS FOR SPECIFICATIONS & LOCATIONS
	CEILING MOUNTED OCCUPANT SENSOR	REFER TO CONSULTANT'S DRAWINGS FOR SPECIFICATIONS & LOCATIONS
	CEILING OR WALL MOUNTED SMOKE DETECTOR	REFER TO CONSULTANT'S DRAWINGS FOR SPECIFICATIONS & LOCATIONS


LEGEND : WALL SCONCE & PENDANT MOUNTING HEIGHTS	
NOTE: ALL PENDANT DIMENSIONS ARE FROM UNDERSIDE OF FIXTURE TO FINISHED FLOOR. ALL WALL SCONCE DIMENSIONS ARE FROM CENTRE OF FIXTURE TO FINISHED FLOOR	
 L.9	2150MM
 L.28	2750MM

REFLECTED CEILING NOTES


1. MECHANICAL AND ELECTRICAL WORK TO COMPLY WITH THE REQUIREMENTS OF THE BUILDING LANDLORD AND AUTHORITIES, HAVING JURISDICTION.
2. REFER TO DESIGN DRAWINGS FOR LOCATION OF CEILING FIXTURES. REFER TO MECHANICAL DRAWINGS FOR SIZES OF DUCTS AND PIPES.
3. CONTRACTOR TO CROSS REFERENCE BETWEEN DESIGNER'S ELECTRICAL DRAWINGS, DESIGNER'S MECHANICAL DRAWINGS AND SITE CONDITIONS. REFER TO CORRESPONDENCE TO DESIGNER FOR CLARIFICATION.
4. CONTRACTOR TO PROVIDE PIPING IN PERMANENT CEILING TO ACCOMMODATE SPRINKLER, EXIT LIGHTS, ACCESS PIPES, RECESSED DOWN LIGHTS, DEFUSERS, ETC. REFER TO SCHEDULED QUANTITIES, PLAN, DIMENSIONS, DRAWINGS AND SPECIFICATIONS.
5. LIGHT FIXTURES AND SWITCHES TO BE LOCATED IN ACCORDANCE WITH DESIGNER'S REQUIREMENTS. REFER TO CORRESPONDENCE TO DESIGNER FOR CLARIFICATION.
6. CONTRACTOR TO PROVIDE AIR TRANSFER DUCTS IN ACCORDANCE WITH MECHANICAL DRAWINGS WHERE CONSTRUCTION OCCURS ABOVE SUSPENDED CEILING TO U/S OF CEILING.
7. REFER TO DIMENSIONING DRAWINGS FOR LIFE SAFETY SYSTEMS.
8. ELECTRICAL CONSULTANT TO CONFIRM QUANTITY AND LOCATION OF LUMINAIRES REQUIRED TO ACHIEVE LISTED LEVELS AND DISTRIBUTION AS REQUIRED BY LOCAL GOVERNING CODES AND REGULATIONS.
9. ALL LIGHT FIXTURES TO BE ON OWNERS.
10. CONTRACTOR TO CONFIRM CEILING HEIGHT CONDITIONS AND NOTIFY DESIGNER OF ANY DISCREPANCIES.
11. CONTRACTOR TO BE RESPONSIBLE TO VERIFY QUANTITY OF FIXTURES PRIOR TO ORDERING AND INSTALLATION.

Notes:

1. CONTRACTOR AND ALL SUB-TRADES SHALL VERIFY ALL SITE DIMENSIONS, ALL DRAWINGS, DETAILS AND SPECIFICATIONS. CORRECT ANY DISCREPANCIES TO THE INTERIOR DESIGNERS IN WRITING FOR APPROVAL BEFORE PROCEEDING WITH THE WORK.
2. CONTRACTOR AND SUB-CONTRACTORS, BEFORE PROCEEDING WITH WORK, MUST SUBMIT ALL MATERIALS AND FINISHES TO THE INTERIOR DESIGNER FOR QUALITY AND FINISH TO THE INTERIOR DESIGNER.
3. CONTRACTOR MUST COMPLY WITH THE CONTRACT DOCUMENTS, PERFORMANCE REQUIREMENTS, APPLICABLE CODES AND REGULATIONS.
4. ALL DRAWINGS AND SPECIFICATION MATERIAL, HEREIN CONSTITUTE THE ORIGINAL AND UNPUBLISHED WORK OF "I BY IV DESIGN ASSOCIATES INC." AND SHALL NOT BE REPLICATED, USED OR DISCLOSED WITHOUT PRIOR WRITTEN CONSENT OF "I BY IV DESIGN ASSOCIATES INC."
5. DRAWINGS NOT TO BE SCALED

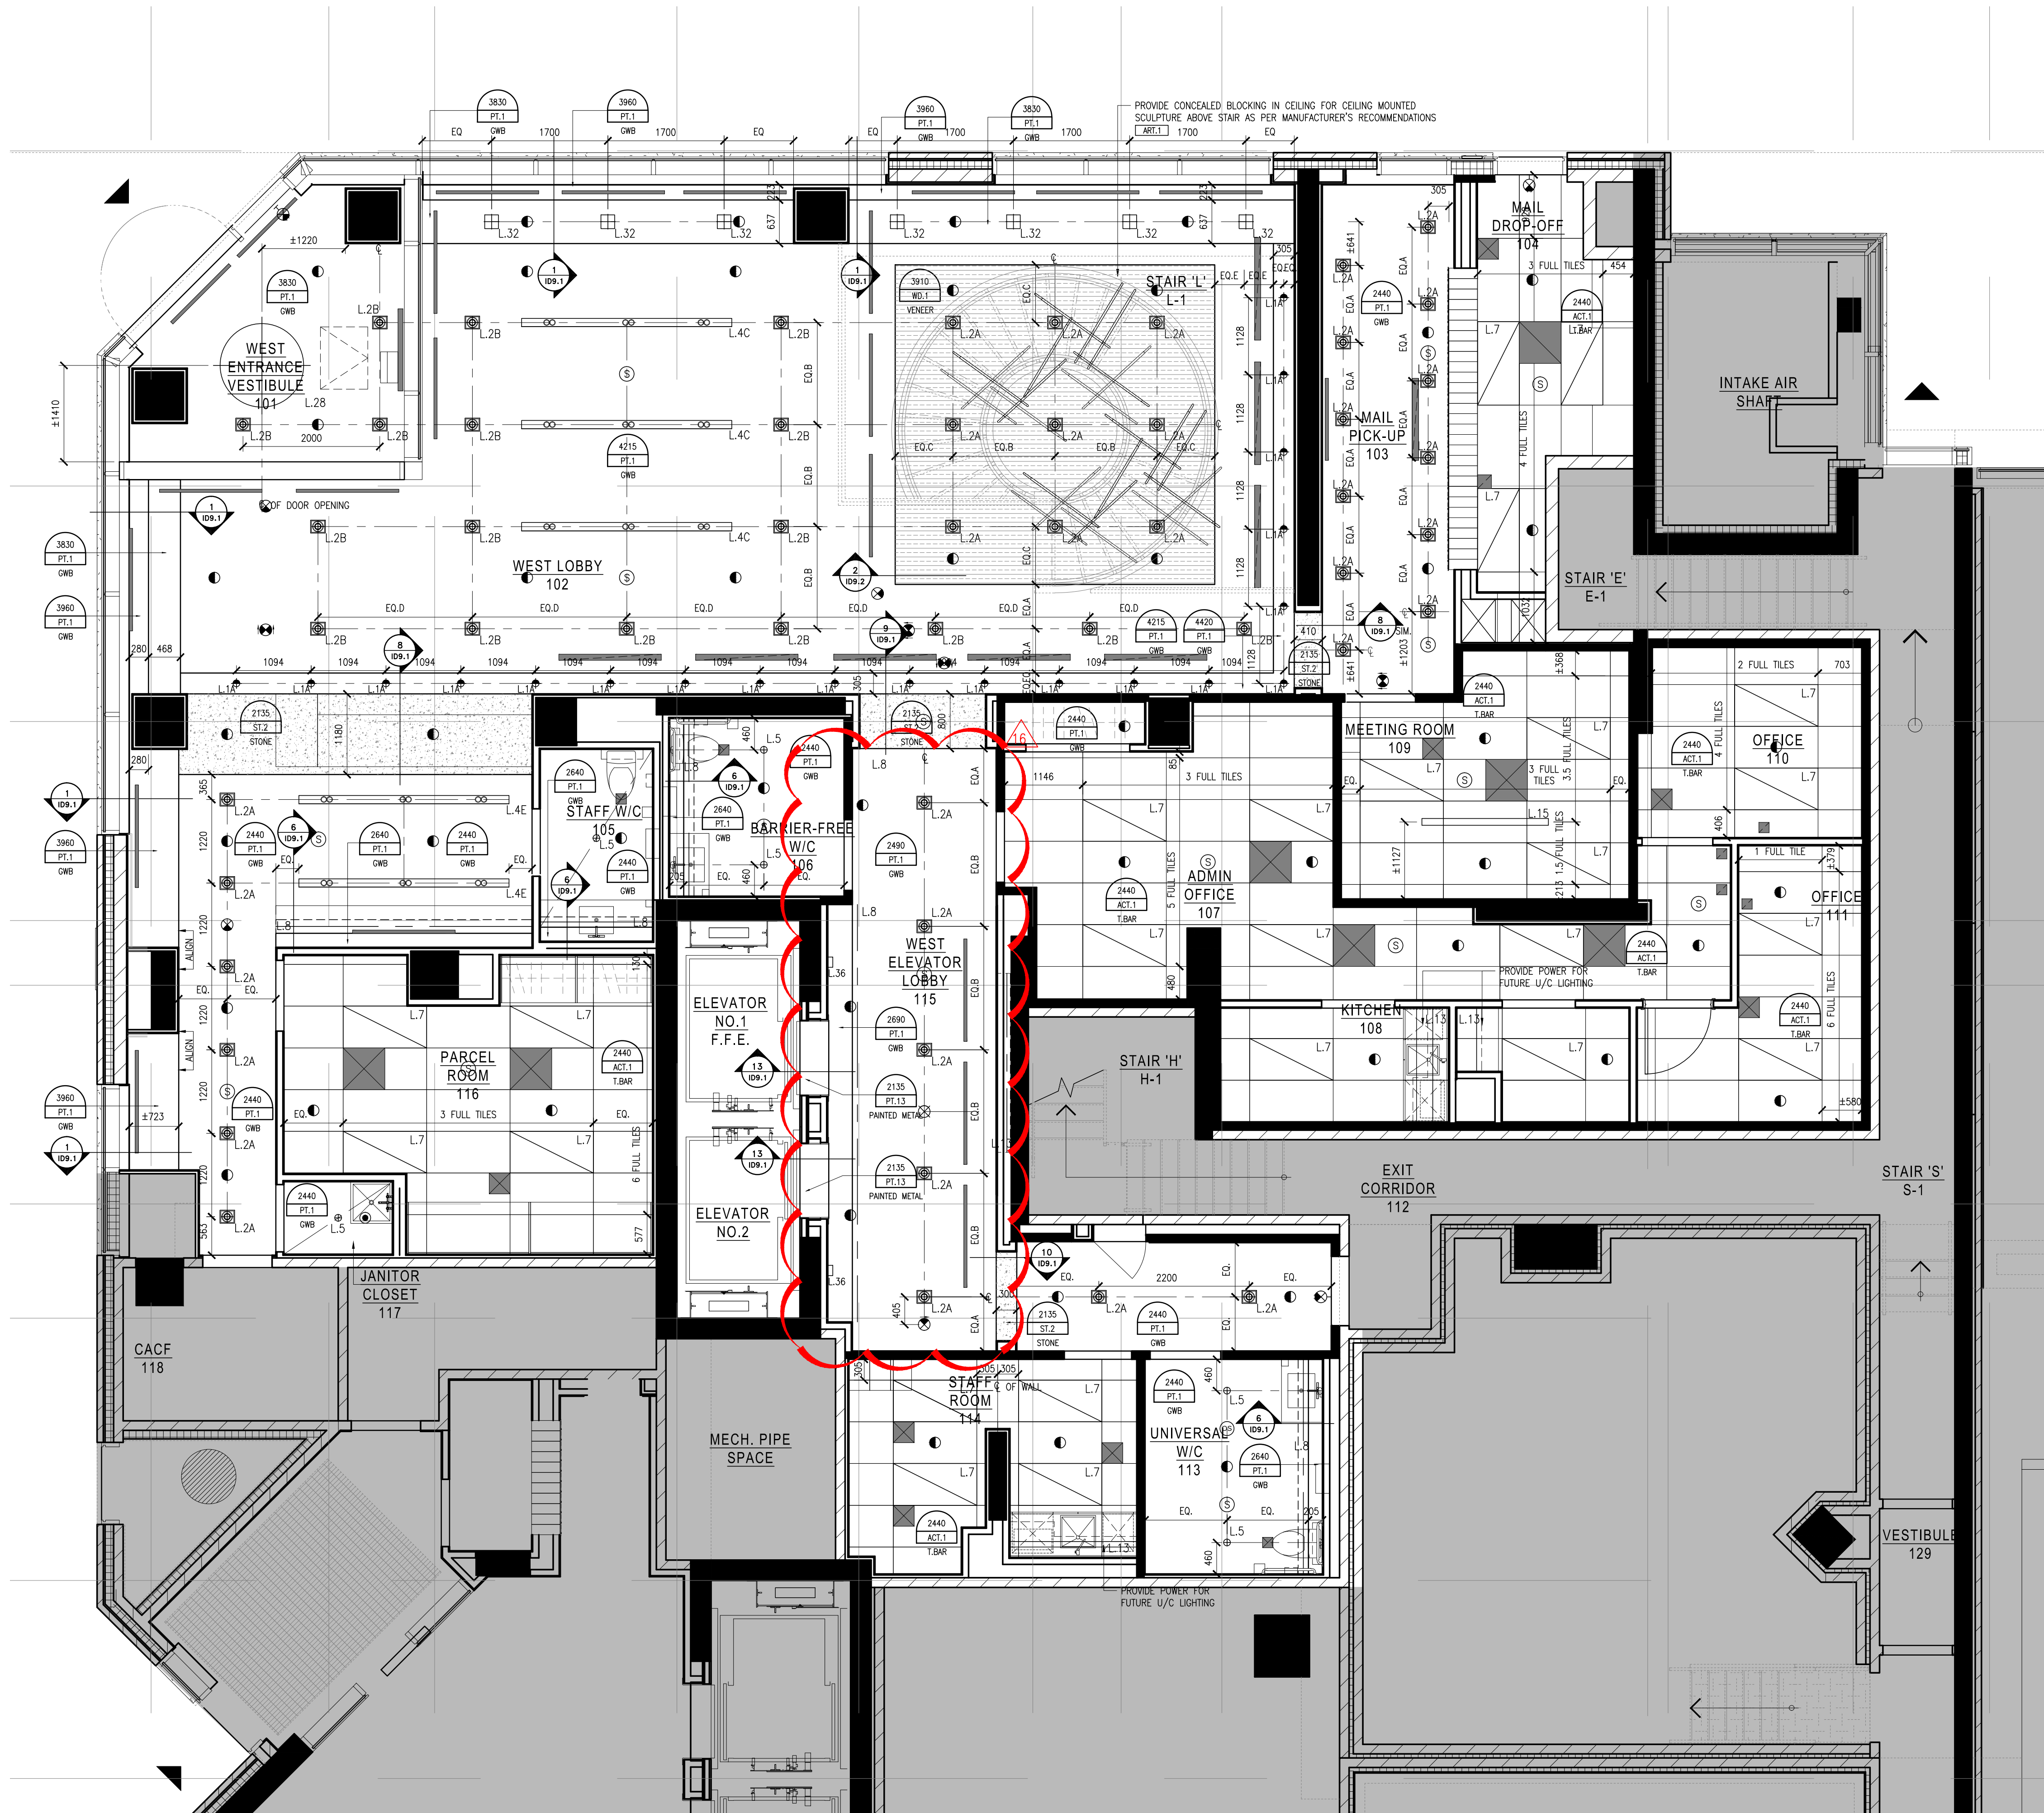

1 REFLECTED CEILING PLAN
103.6 SCALE 1:50

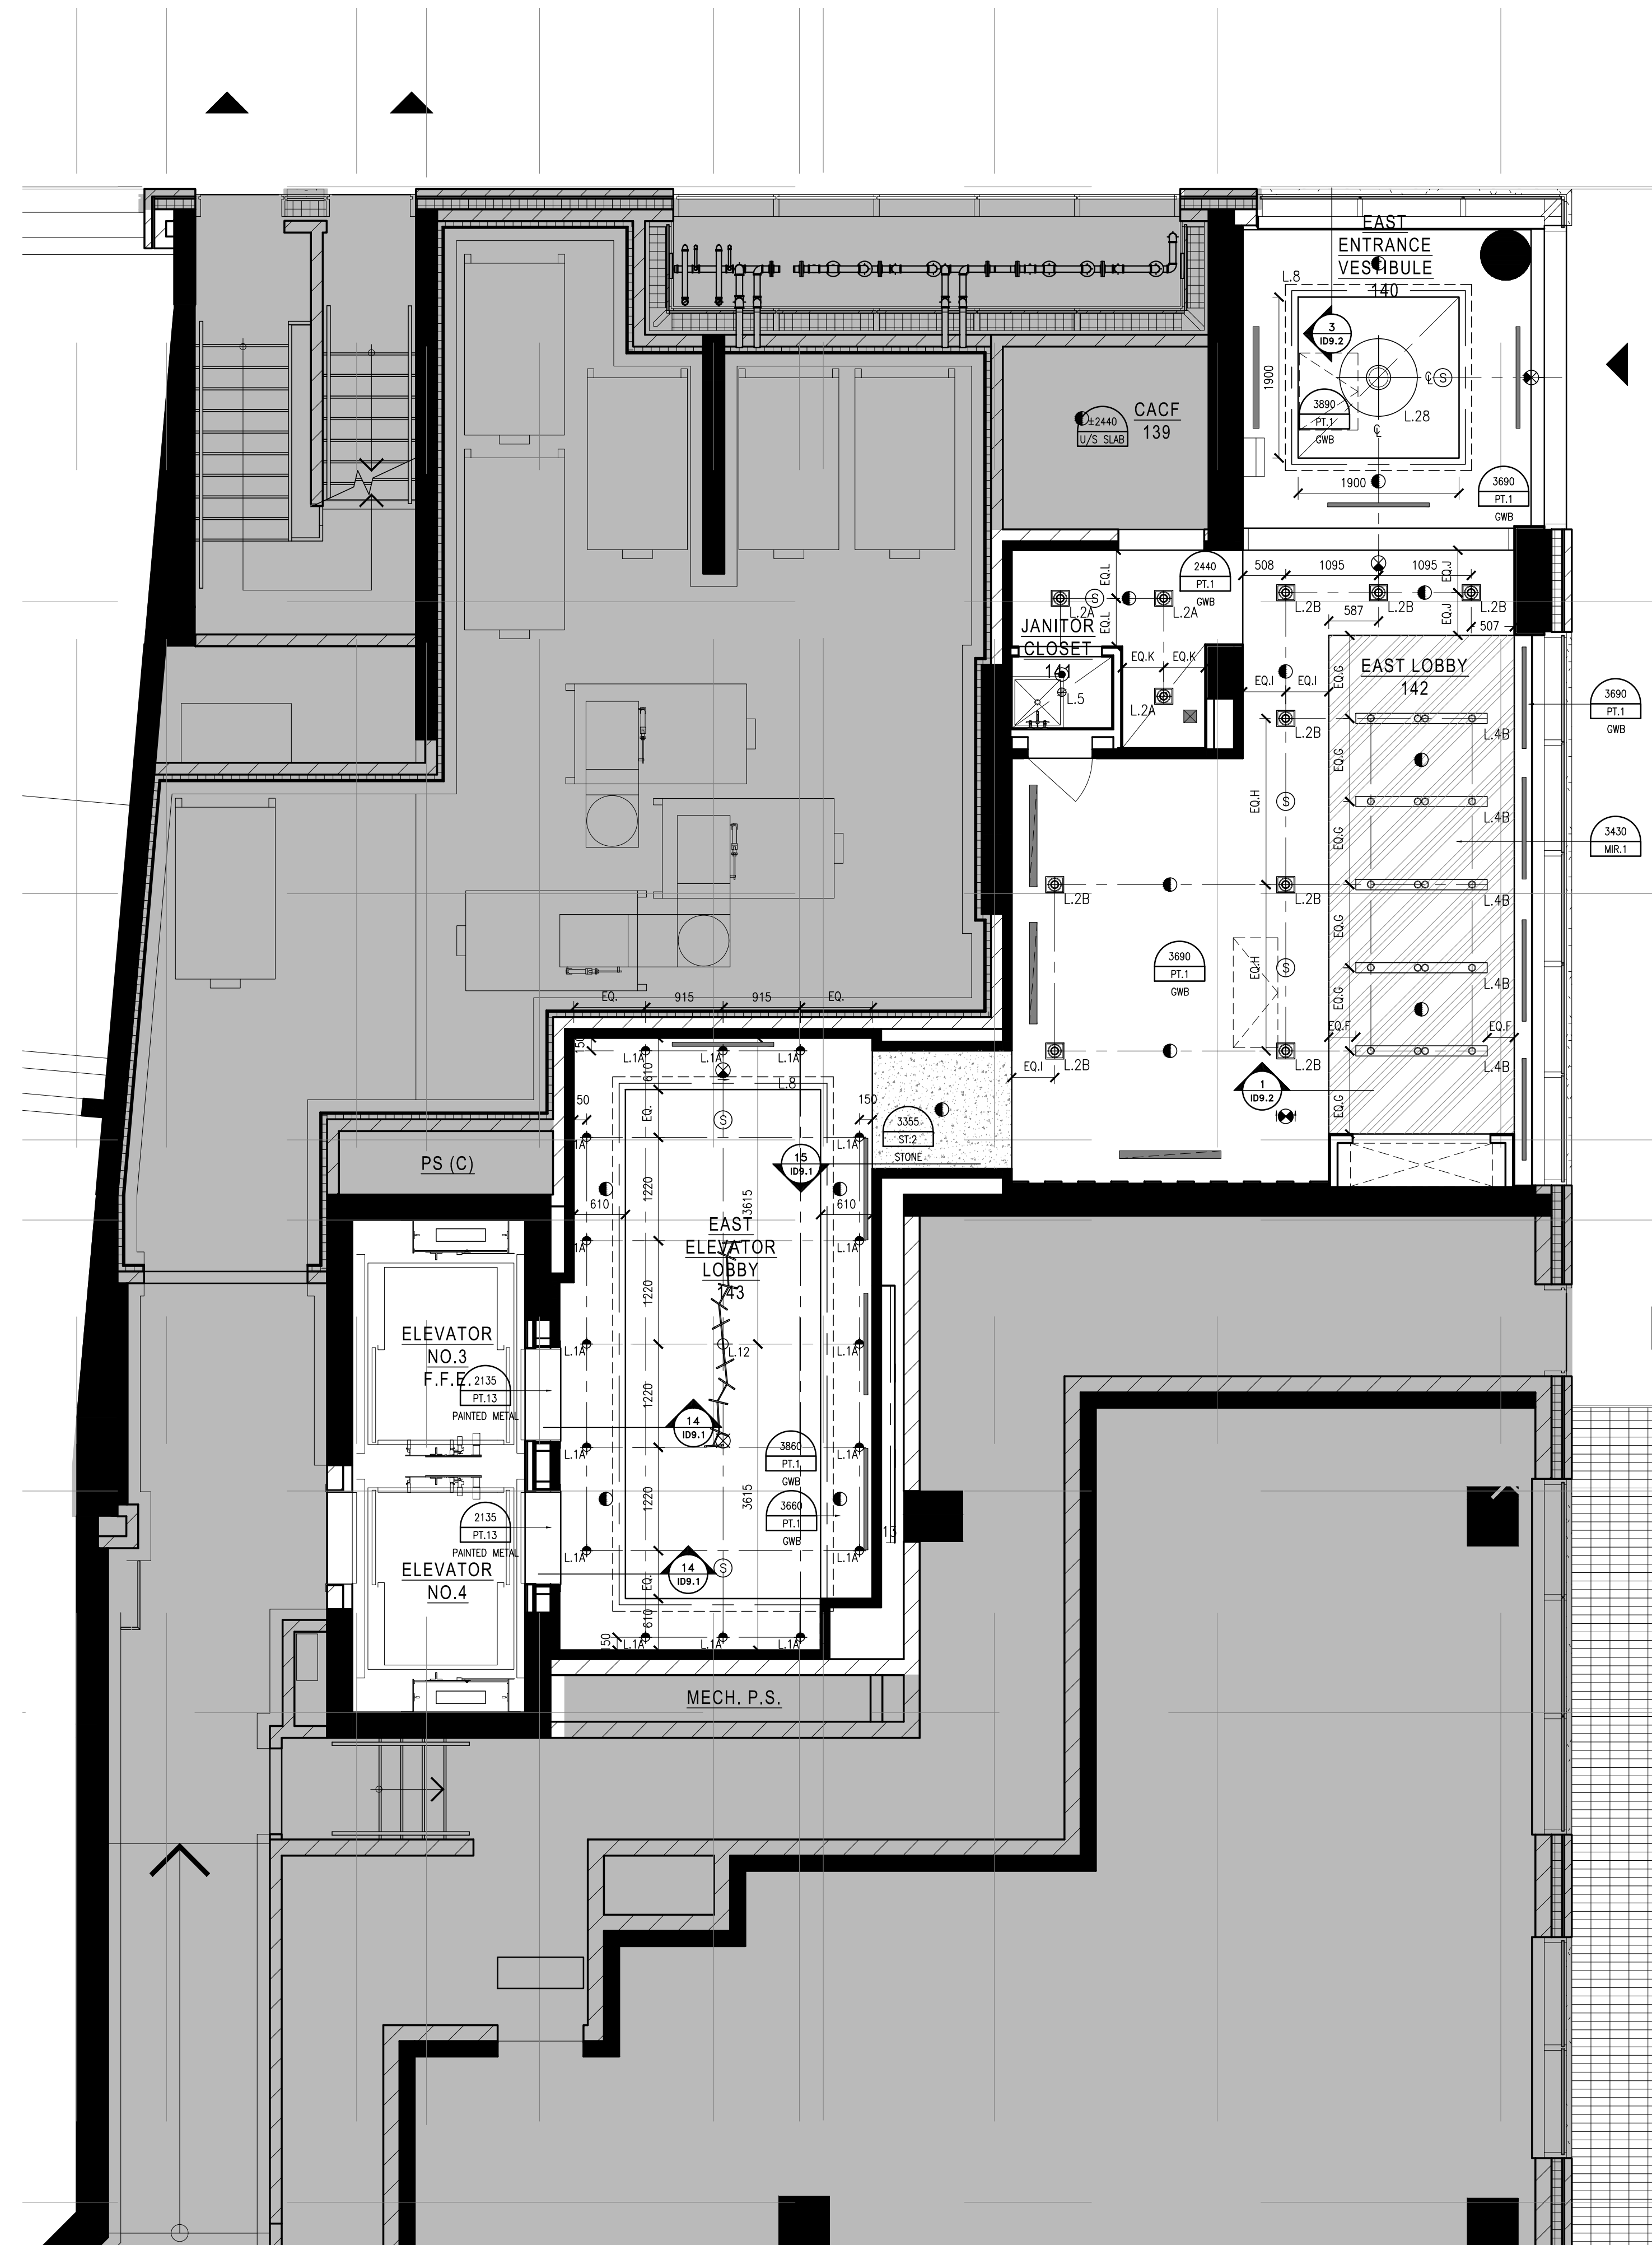

2 REFLECTED CEILING PLAN
ID3.6 SCALE 1:50

Hines TRIDEL®

AQUAVISTA

AT BAYSIDE TORONTO
1 EDGEWATER DRIVE, TORONTO ONTARIO



II BY IV
DESIGN

77 MOWAT AVENUE, SUITE 109
TORONTO, ONTARIO M5K 3E5 - CANADA
T + 1 416 531 2224

12 DESBROSSES STREET
NEW YORK, NEW YORK 10013 - USA
T + 1 212 392 4952

Drawing Title:

LEVEL 1
REFLECTED CEILING
PLAN

Our Project Number:	
14008	
Designed By:	Detailed By:
DM,KR,VW,SG	DM,KR,VW,SG,BP
Drawing Number:	

ID3.6