


DO NOT SCALE DRAWINGS.

CONTRACTOR MUST VERIFY ALL DRAWINGS, DIMENSIONS, DETAILS AND SPECIFICATIONS, AND REPORT ANY DISCREPANCIES TO UNION 31 INC. BEFORE PROCEEDING WITH WORK. MATERIALS MAY NOT BE SUBSTITUTED WITHOUT WRITTEN APPROVAL FROM UNION 31 INC.
ALL DRAWINGS AND SPECIFICATIONS ARE INSTRUMENTS OF SERVICE AND THE PROPERTY OF UNION 31 INC. WHICH MUST BE RETURNED AT THE COMPLETION OF THE WORK.

PRINTED: 19-Sep-17

ISSUED FOR
AS-BUILT

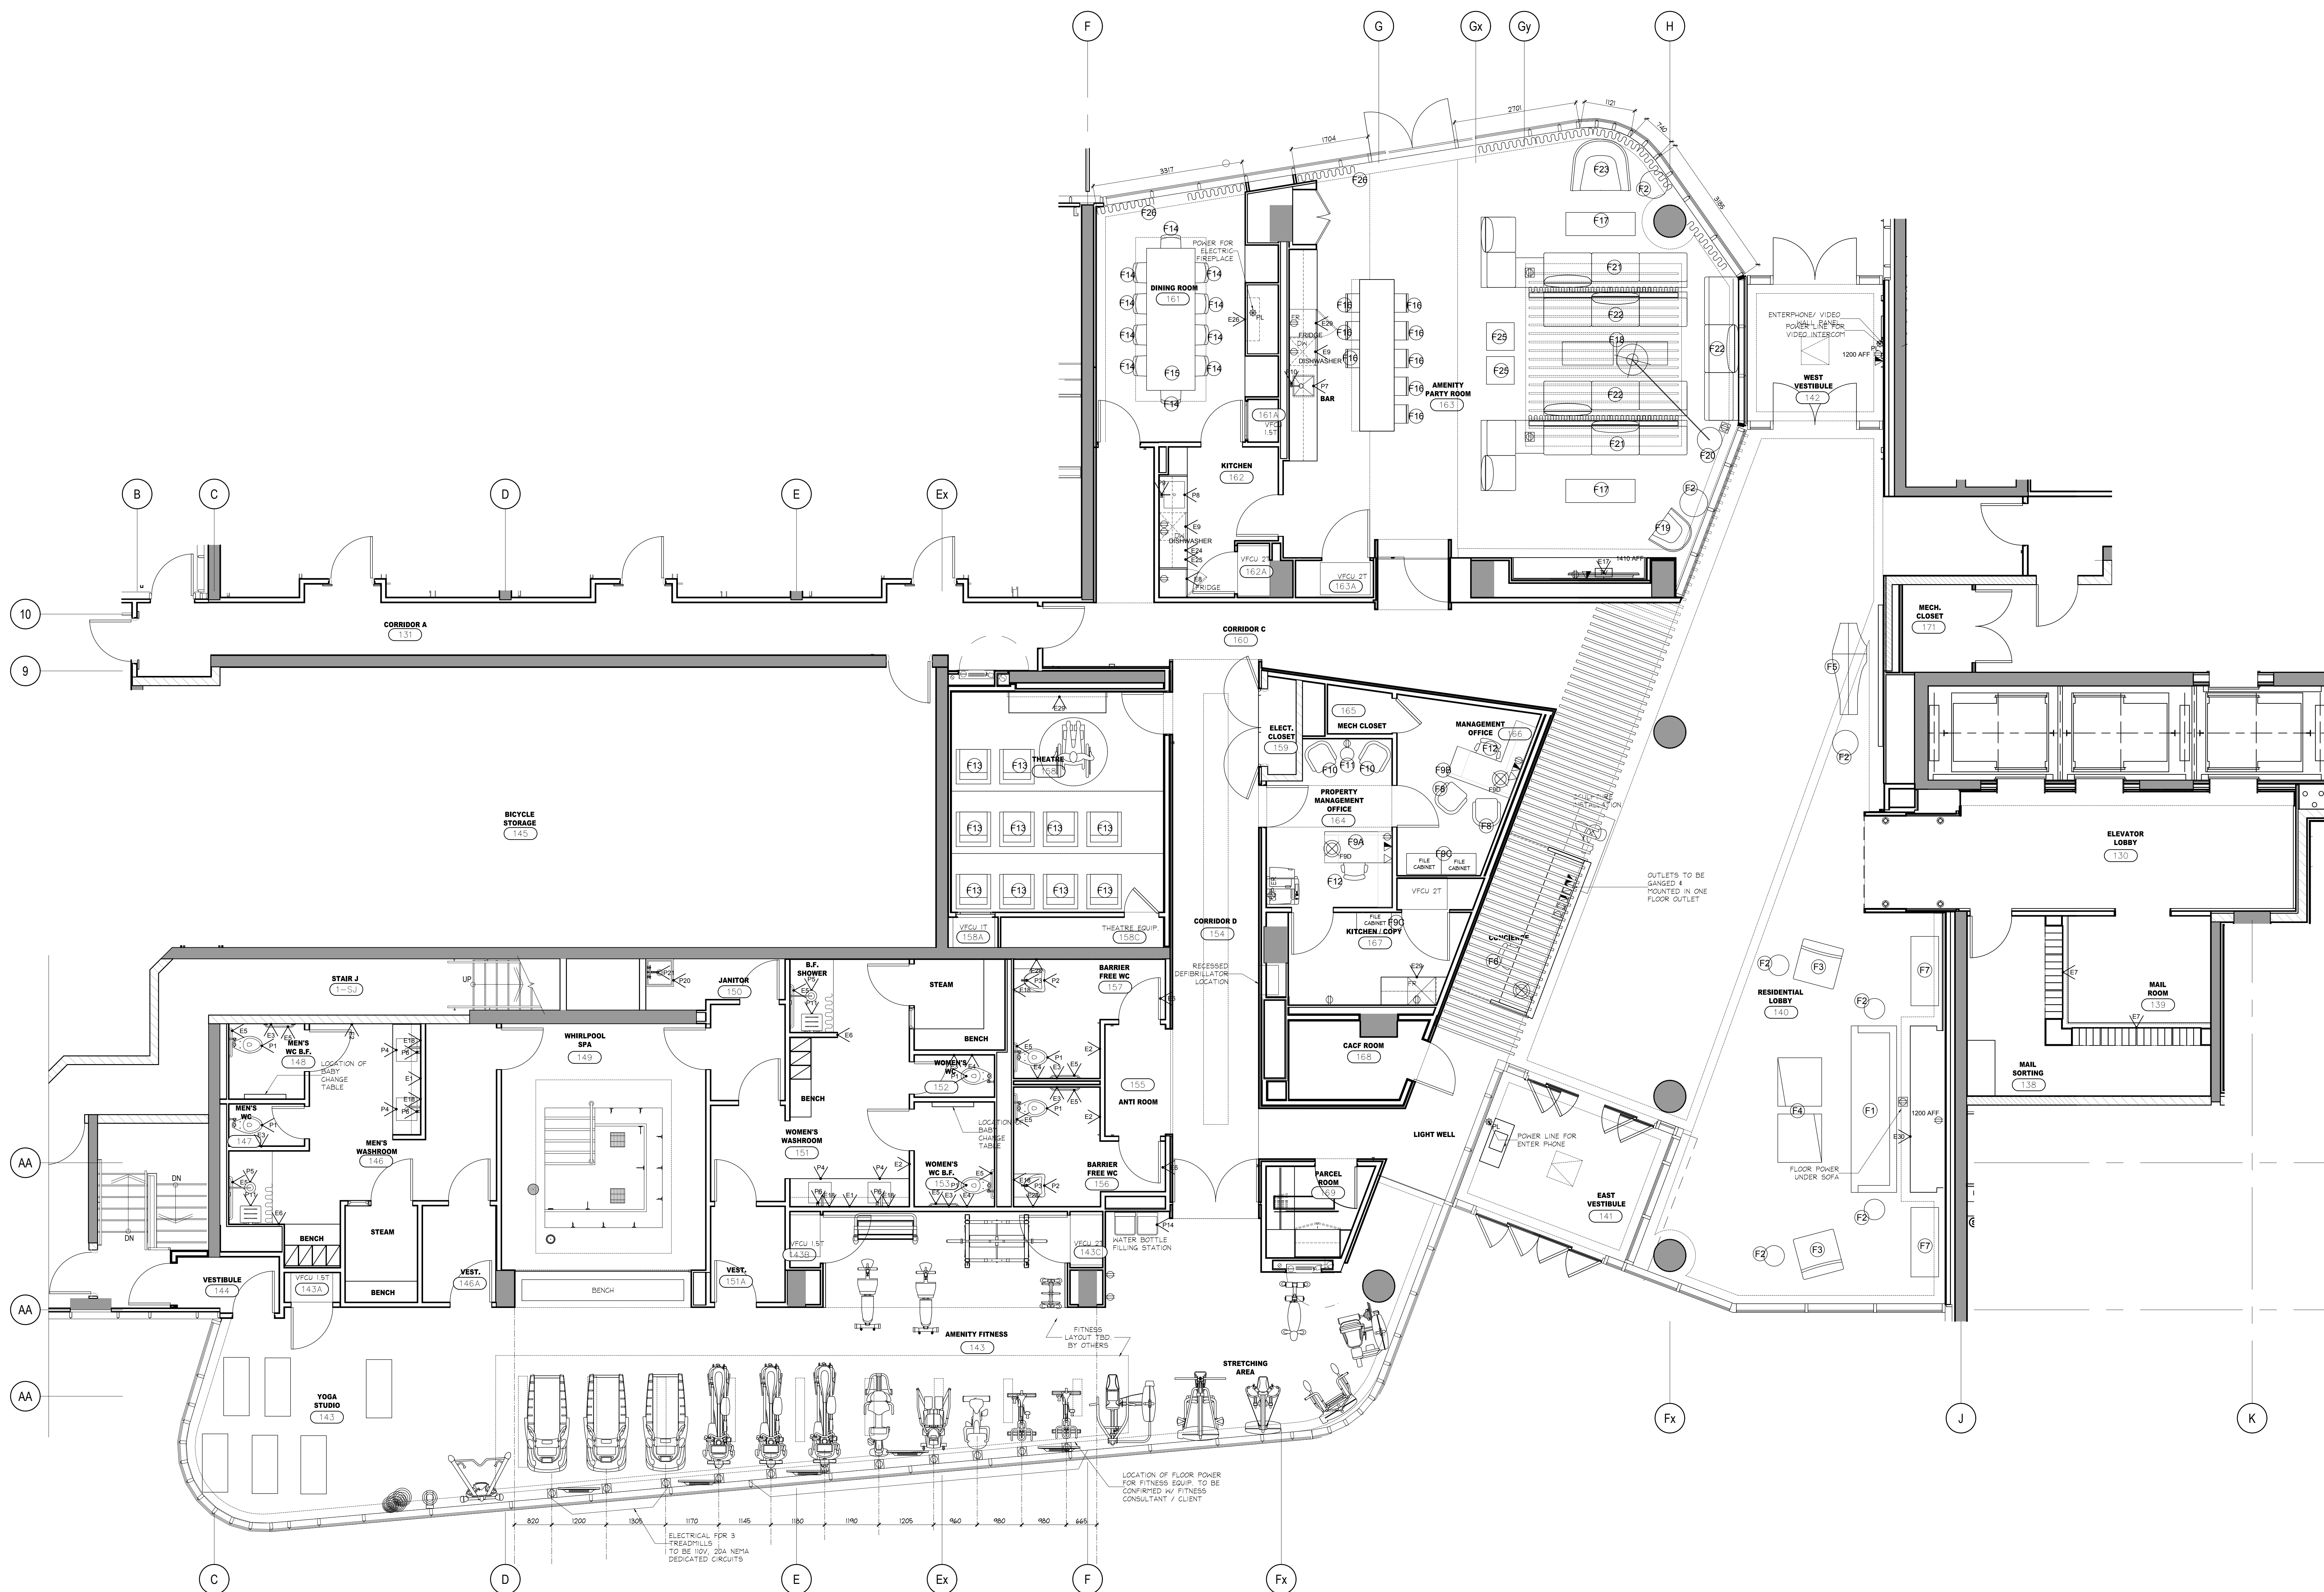

01	31 MAY / 17	ISSUED FOR AS-BUILT	SV
NO.	DATE	COMMENTS	INI
REVISIONS:			

UNION31
 UNION31 INC.
 183 BATHURST STREET, STE. 201
 TORONTO, ON, M5T 2R7, CANADA
 TEL: 416-597-1576 FAX: 416-597-2139

PROJECT NAME:
**ALEXANDRA PARK
 MAIN BUILDING**
 BLOCK 11
 ON, Canada

PROJECT NO.: 13-949
 DRAWINGS:
**GROUND FLOOR
 FURNITURE & POWER PLAN**

DATE STARTED: 07 AUG / 13	DRAWING NO.:
SCALE: 1:50	ID
DRAWN BY: AP	1.1.2
APPROVED BY: KC	

1 FURNITURE & POWER PLAN
 GROUND FLOOR SCALE 1:50